


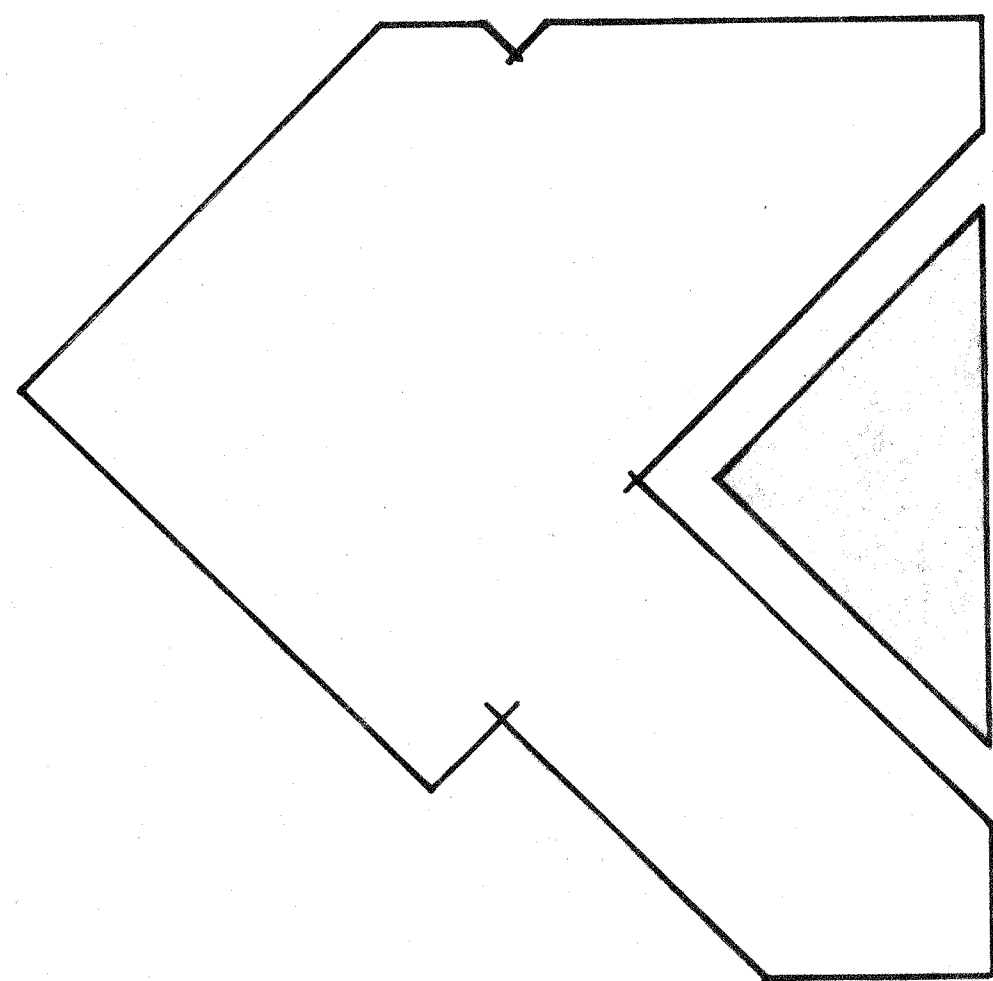

BELLEFONTAINE NEIGHBORS COMMUNITY CENTER

LIST OF DRAWINGS

CIVIL ENGINEERING

- C-1 Grading Profiles
- C-2 Sewer Plan and Details

ARCHITECTURAL

- A-1 Site Plan and Details
- A-2 Swimming Pool Details
- A-3 Architectural Floor Plan
- A-4 Roof and Lower Level Plans and Details
- A-5 Exterior Elevations and Building Sections
- A-6 Wall Sections
- A-7 Wall Sections and Exterior Details
- A-8 Door and Interior Openings Details and Schedule
- A-9 Interior Finish Schedule and Details
- A-10 Interior Details and Elevations
- A-11 Interior Elevations

STRUCTURAL

- S-1 Foundation and Footing Plan
- S-2 Roof Framing Plan
- S-3 Foundation and Footing Details
- S-4 Roof Framing Details
- S-5 Wood Trusses and Details
- S-6 Interior Pool Details
- S-7 Exterior Pool Details
- S-8 Gunitite Pool and Misc. Details

ELECTRICAL

- E-1 Power Riser and Schedules
- E-2 Site and Exterior Pool Plan
- E-3 Reflected Ceiling Plan
- E-4 Power, Signal Systems, and Underwater Lighting Plan

HVAC

- H-1 Floor Plan
- H-2 Sections and Details
- H-3 Schedules and Details

PLUMBING

- P-1 Site Plan and Details
- P-2 Foundation Plan
- P-3 Floor Plan
- P-4 Pool Plans and Details
- P-5 Pool Filters and Details
- P-6 Plumbing Riser Diagrams

GENERAL ARCHITECTURAL REFERENCE SHEETS

- A-3 Architectural Floor Plan
- A-5 Exterior Elevations & Building Sections
- A-6 Wall Sections
- A-7 Wall Sections and Exterior Details

DETAIL
SECTION

SHEET
NUMBER

FOREST HOME DRIVE

ZELLWEGER DRIVE

SITE LOCATION

BIRITZ DRIVE

BELLEFONTAINE ROAD

Job No. 1188

Date: AUG. 5, 1974


Revisions:





























Bellefontaine Neighbors
Community Center

FOR RAYMOND ZIELINSKI


Hastings & Chivetta Architects
7733 Forsyth Boulevard, Clayton, Missouri 63105 314-863-5717
Frank A. Romano & Associates
Hansen Engineering
Heinicke & T.

Engineers
Mechanical
Electrical
Structural
Engineers
Engineers
Engineers

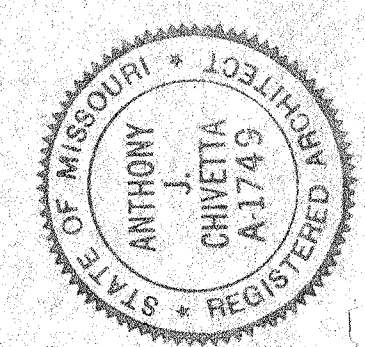


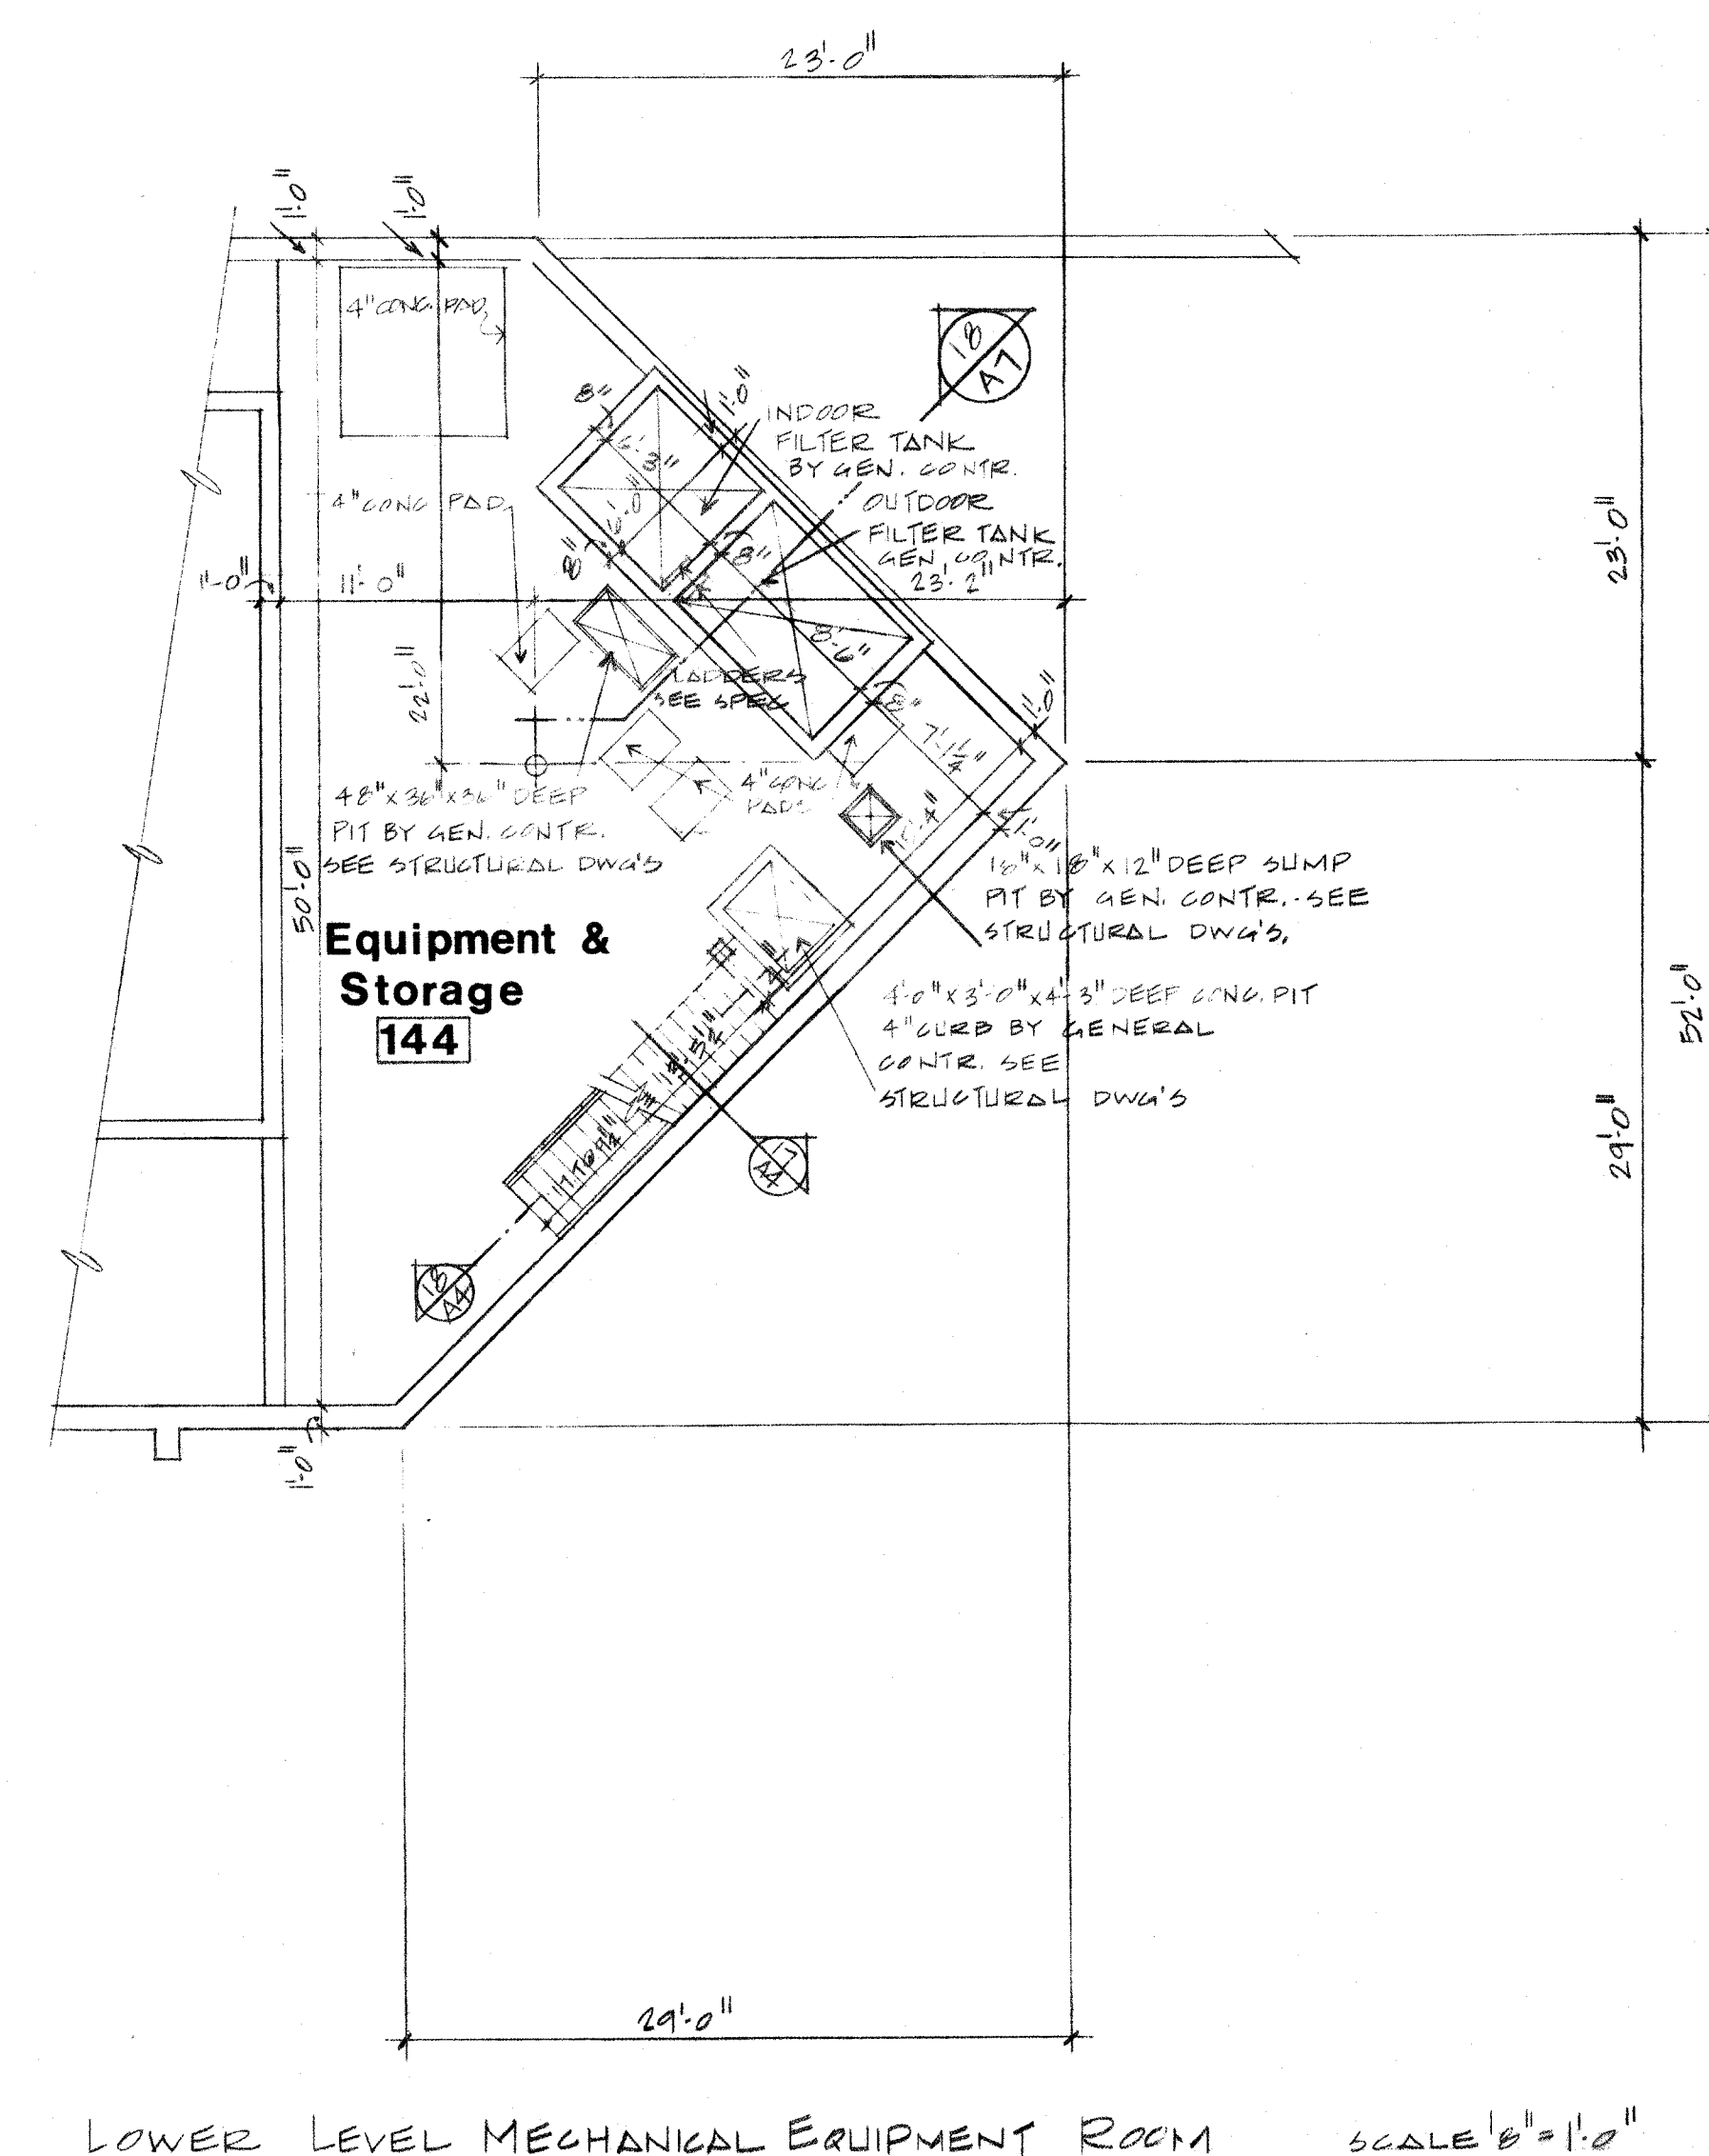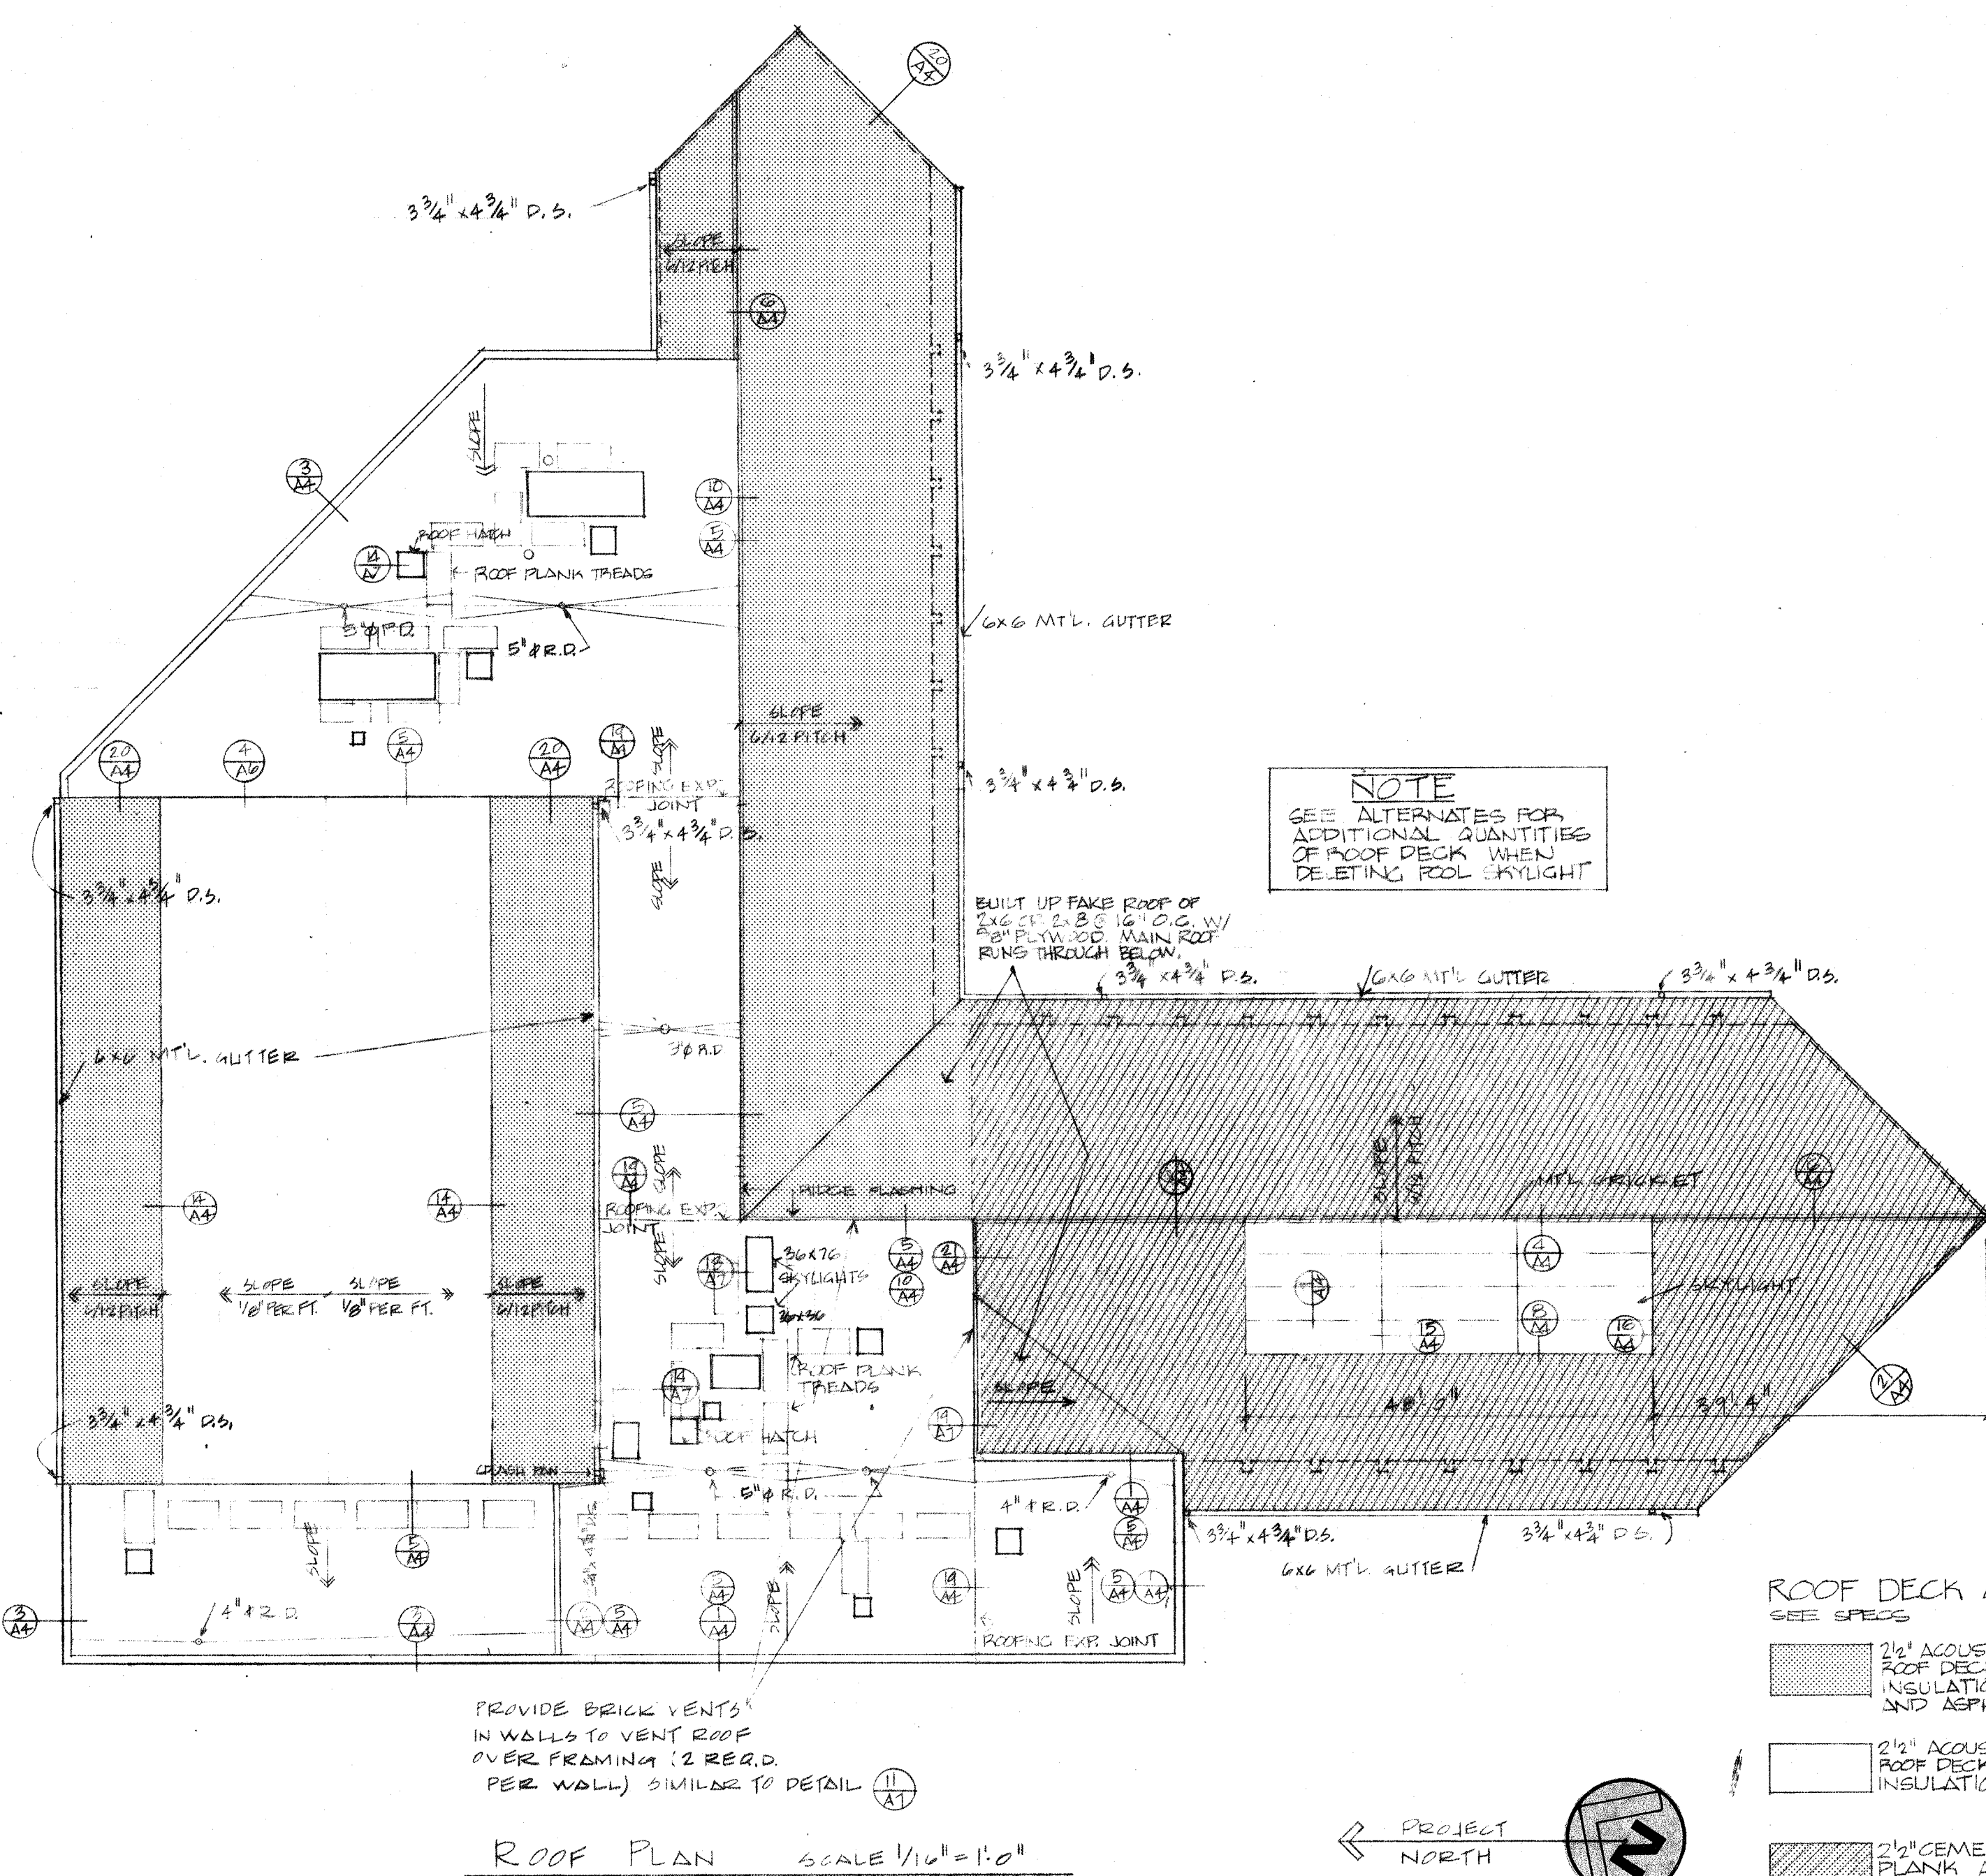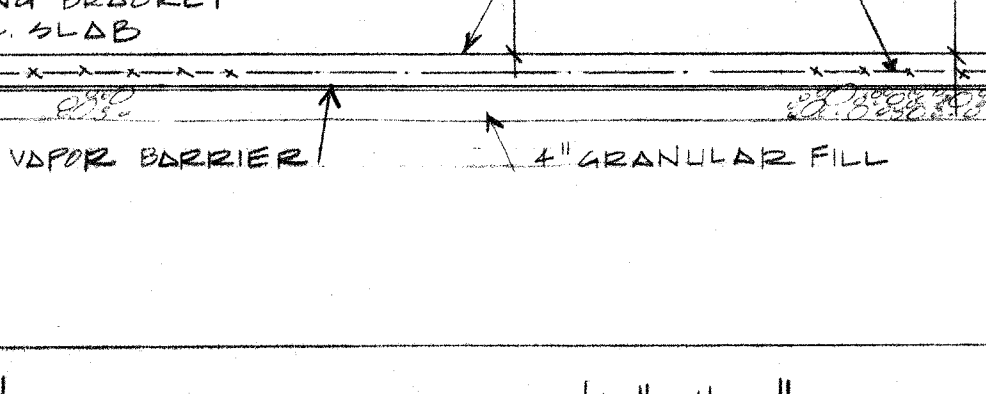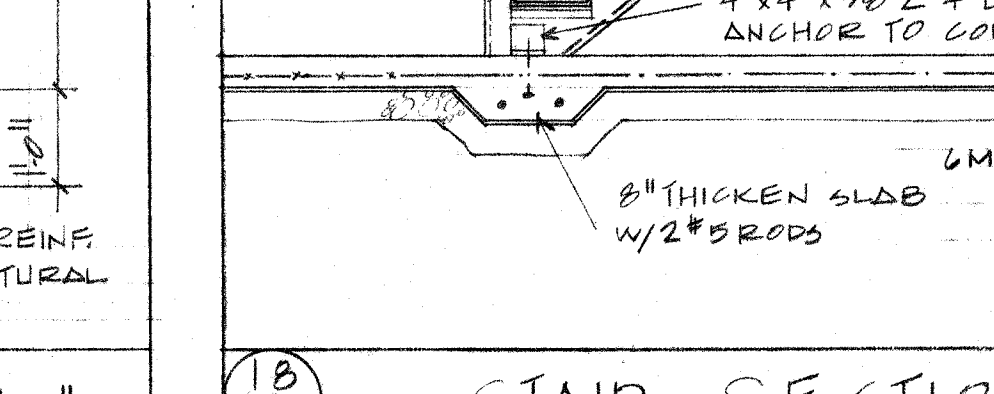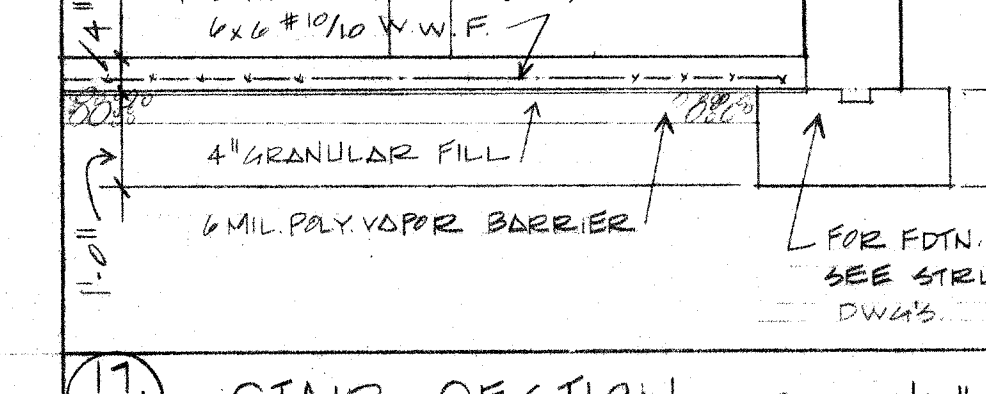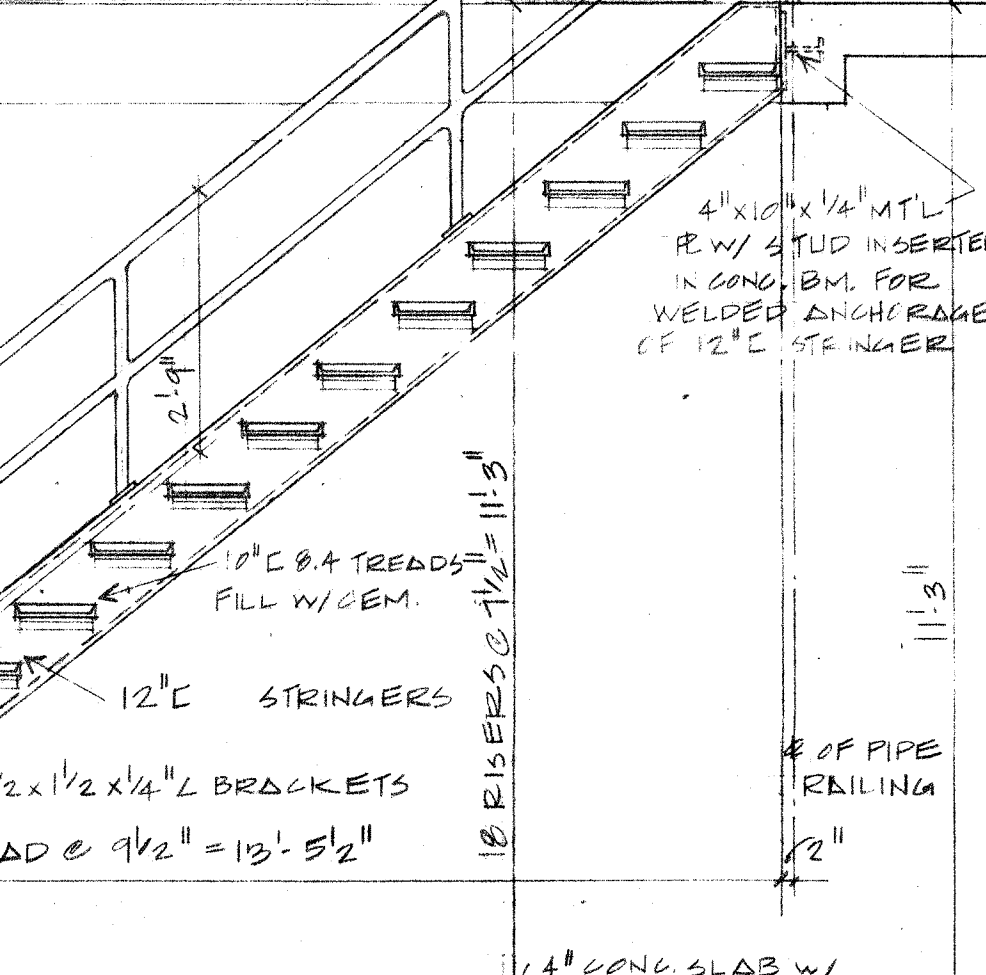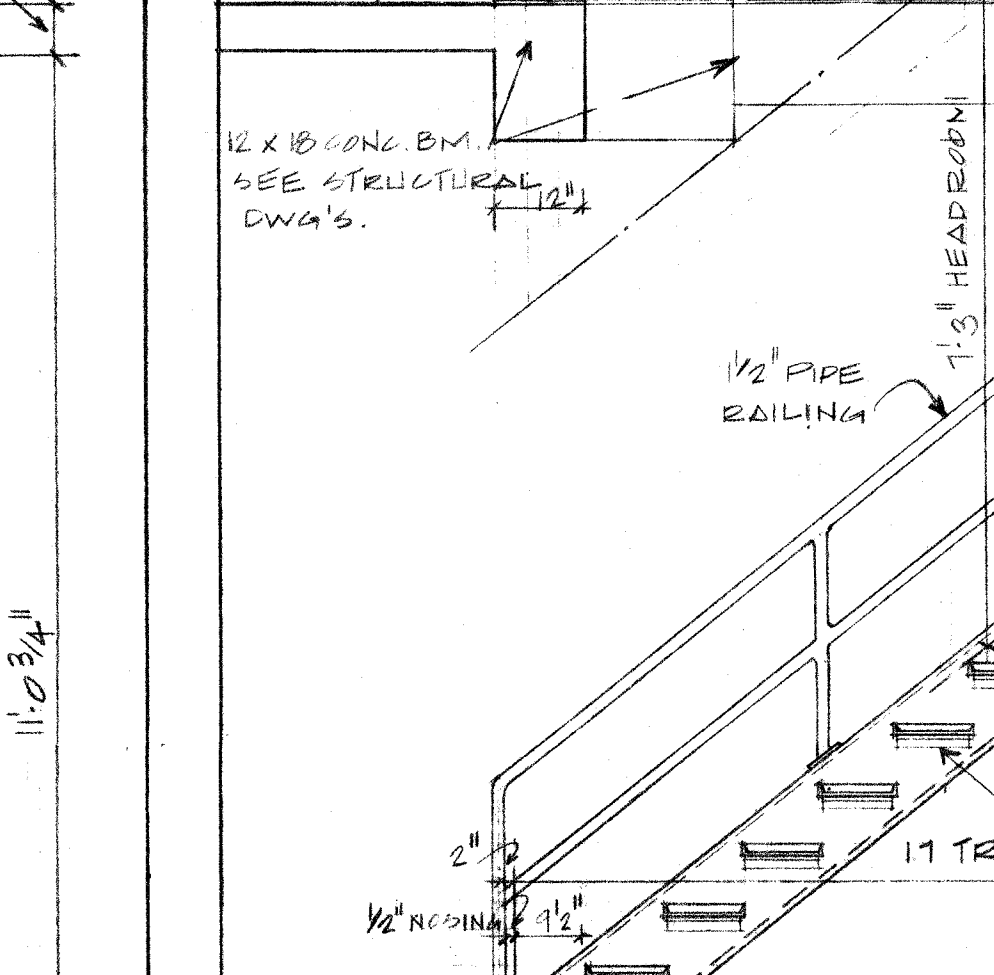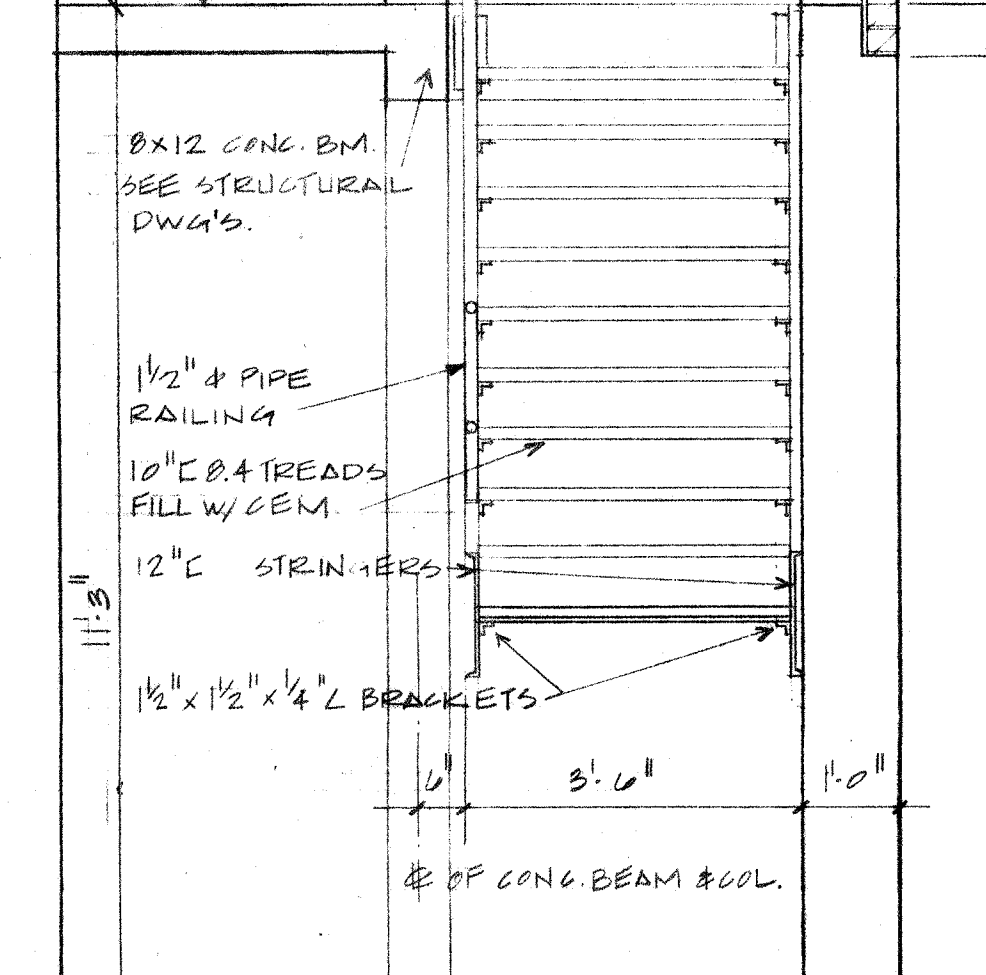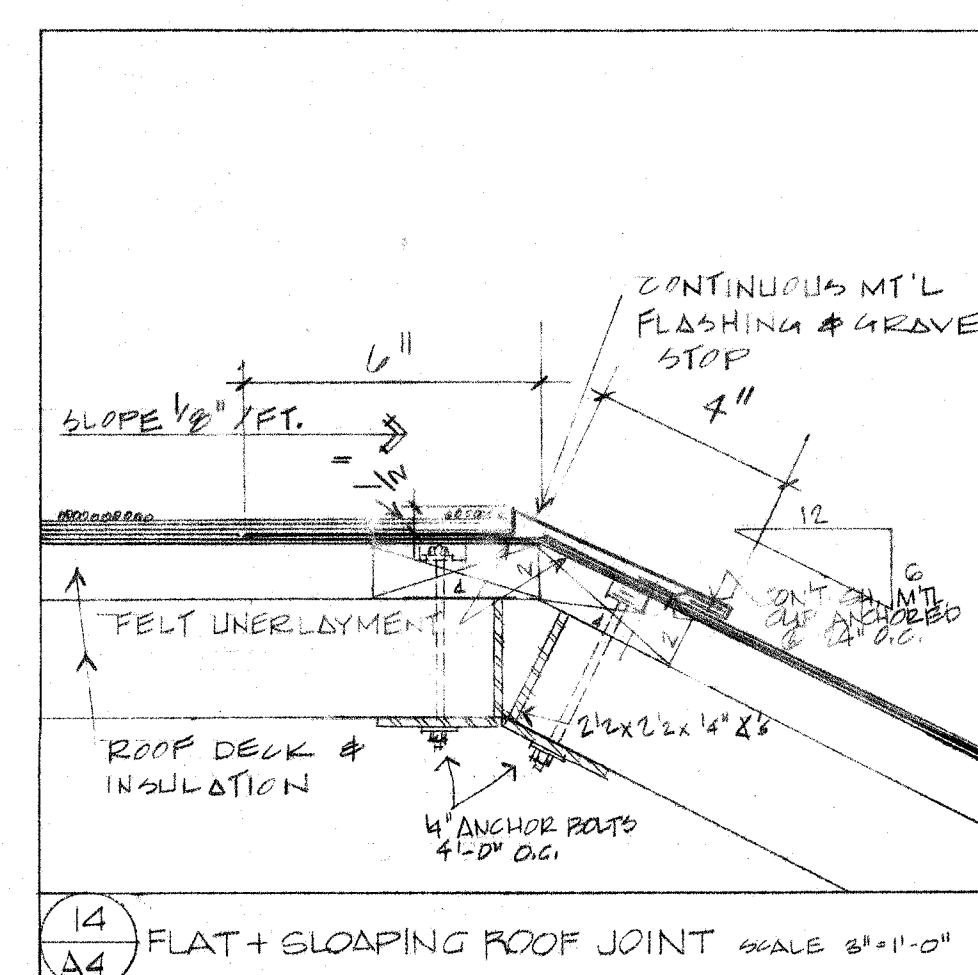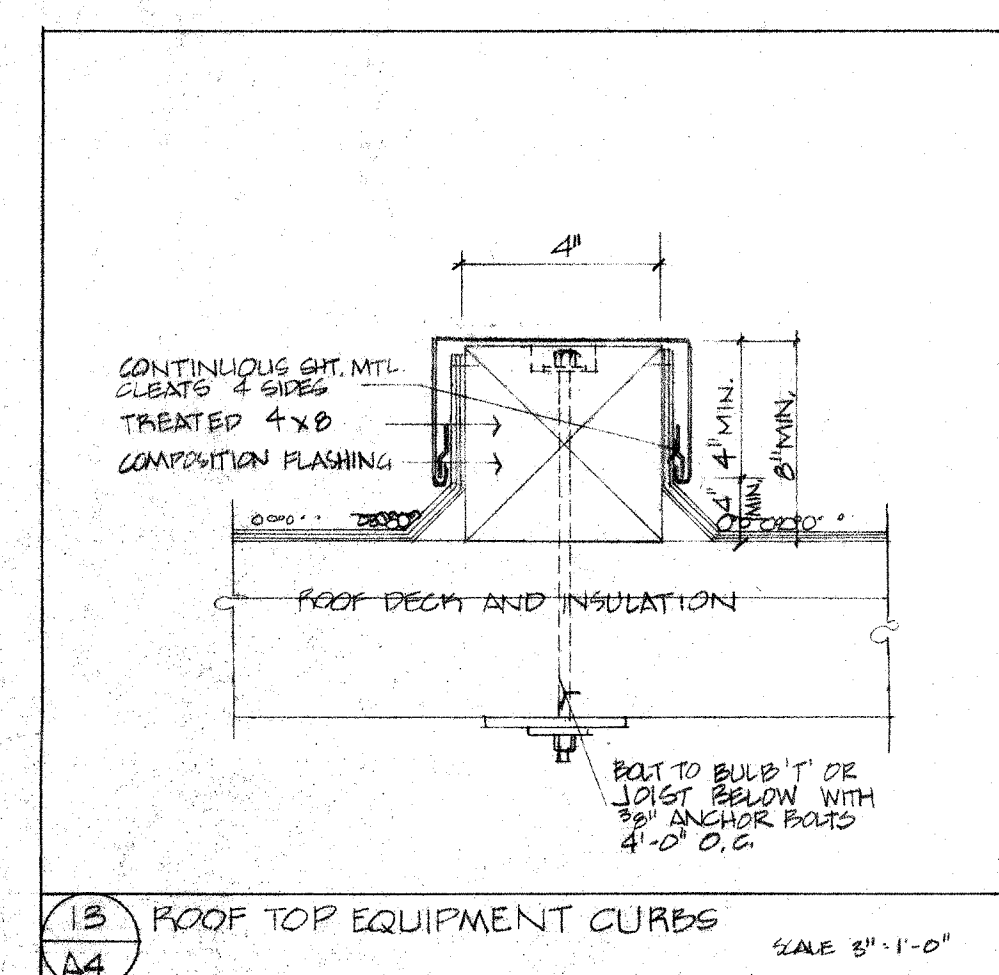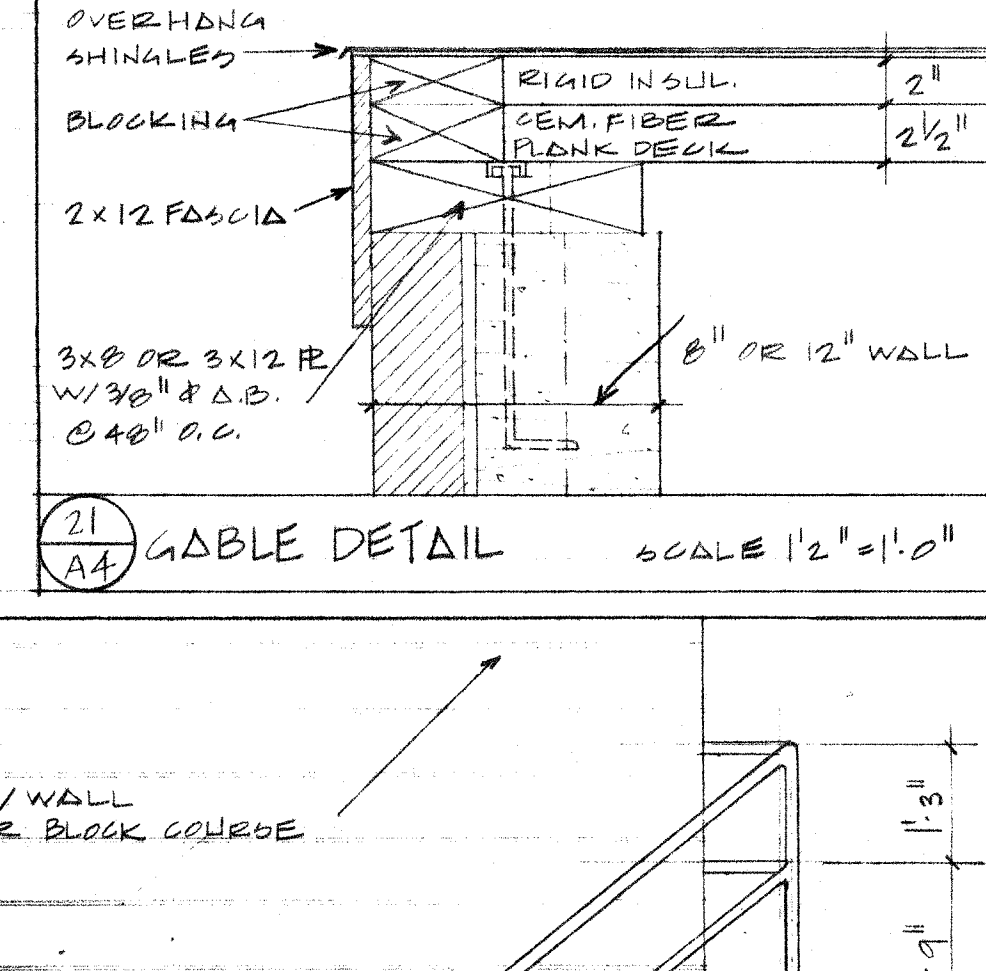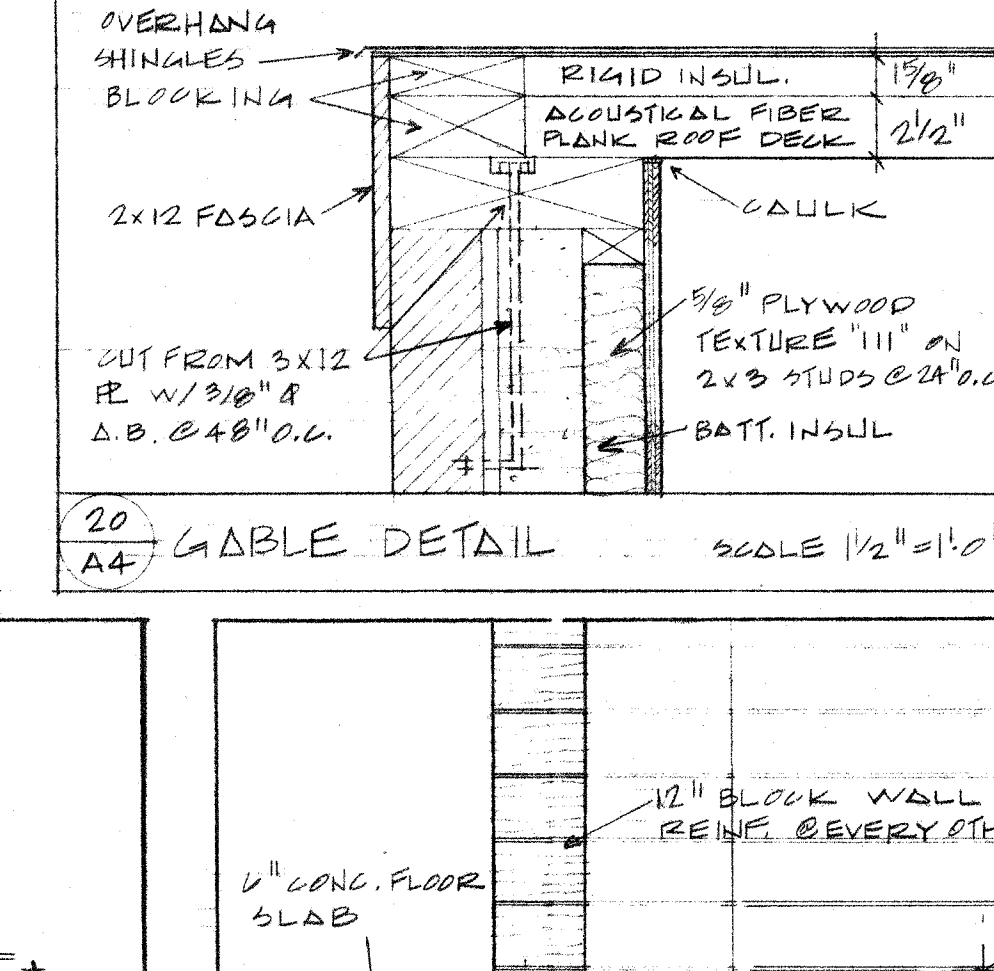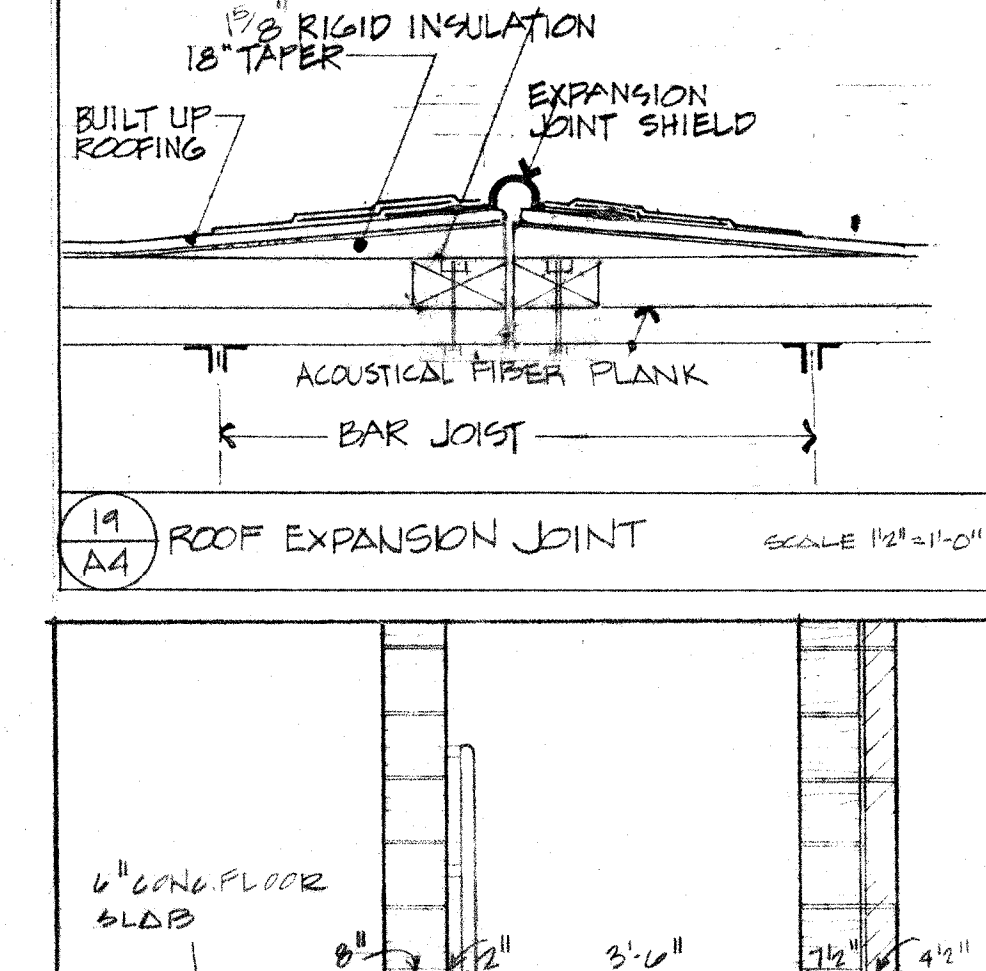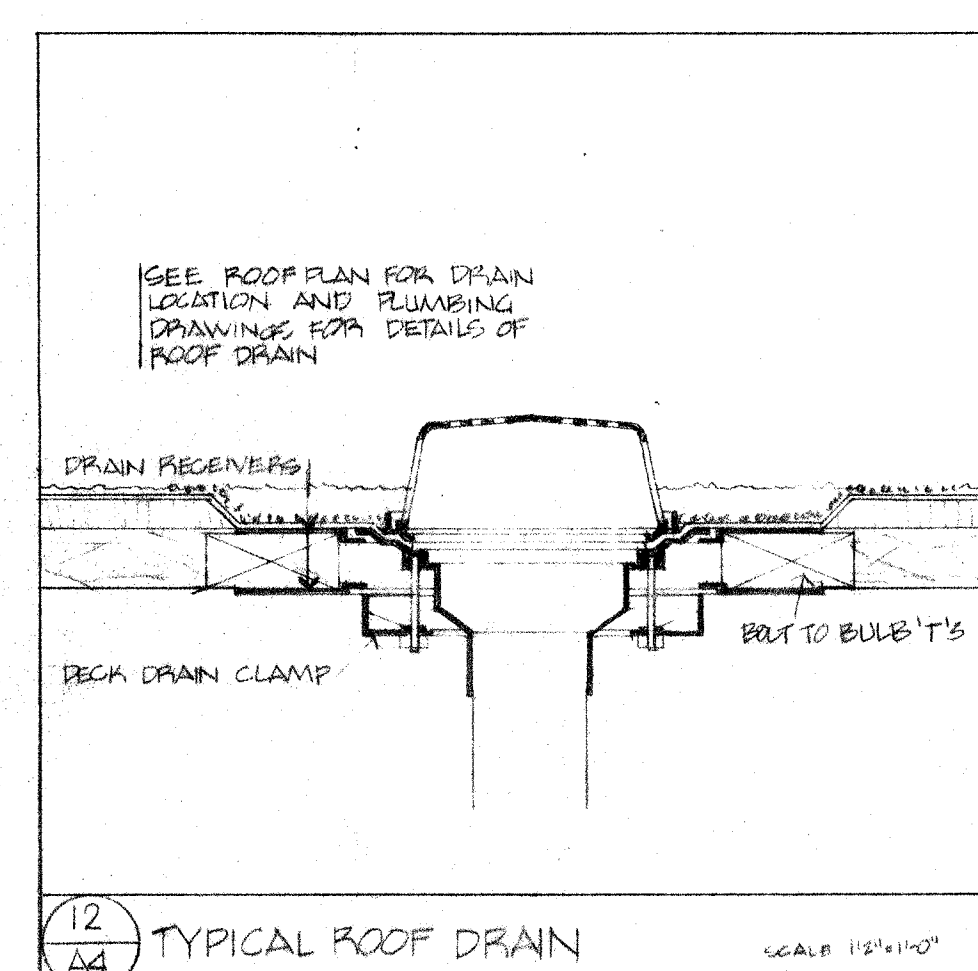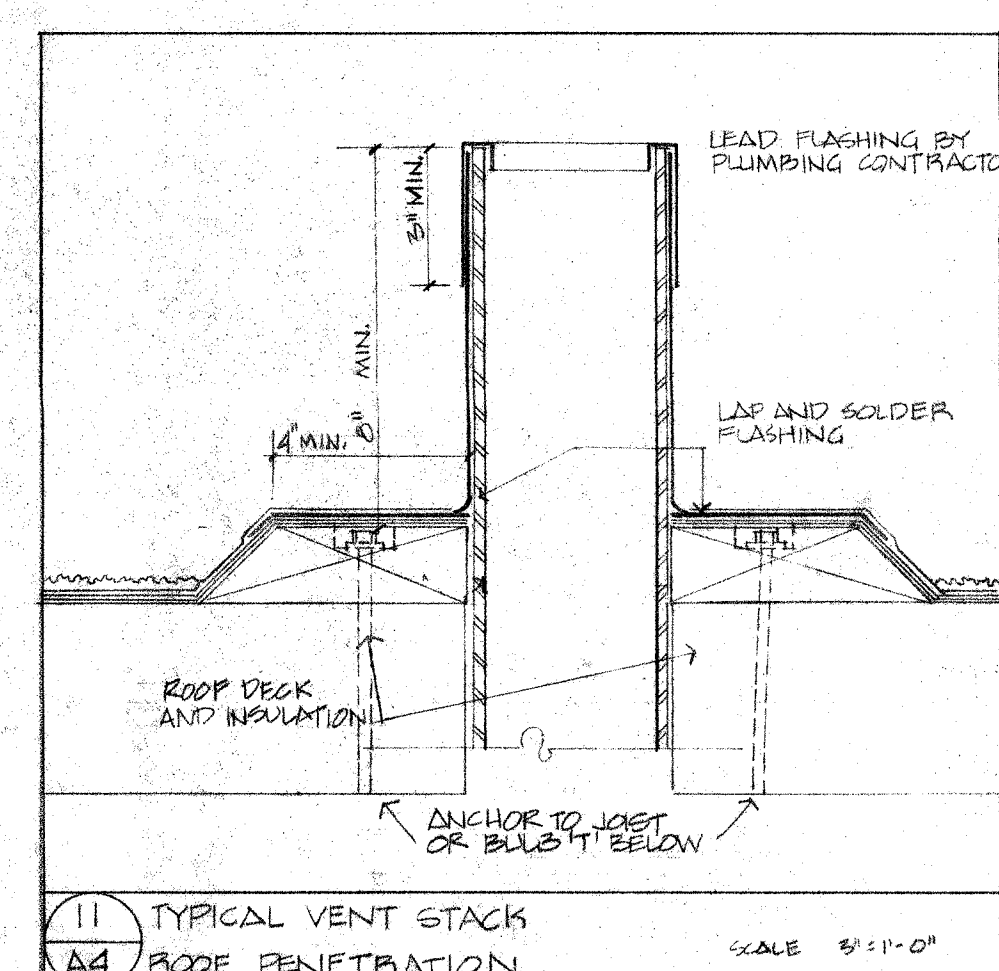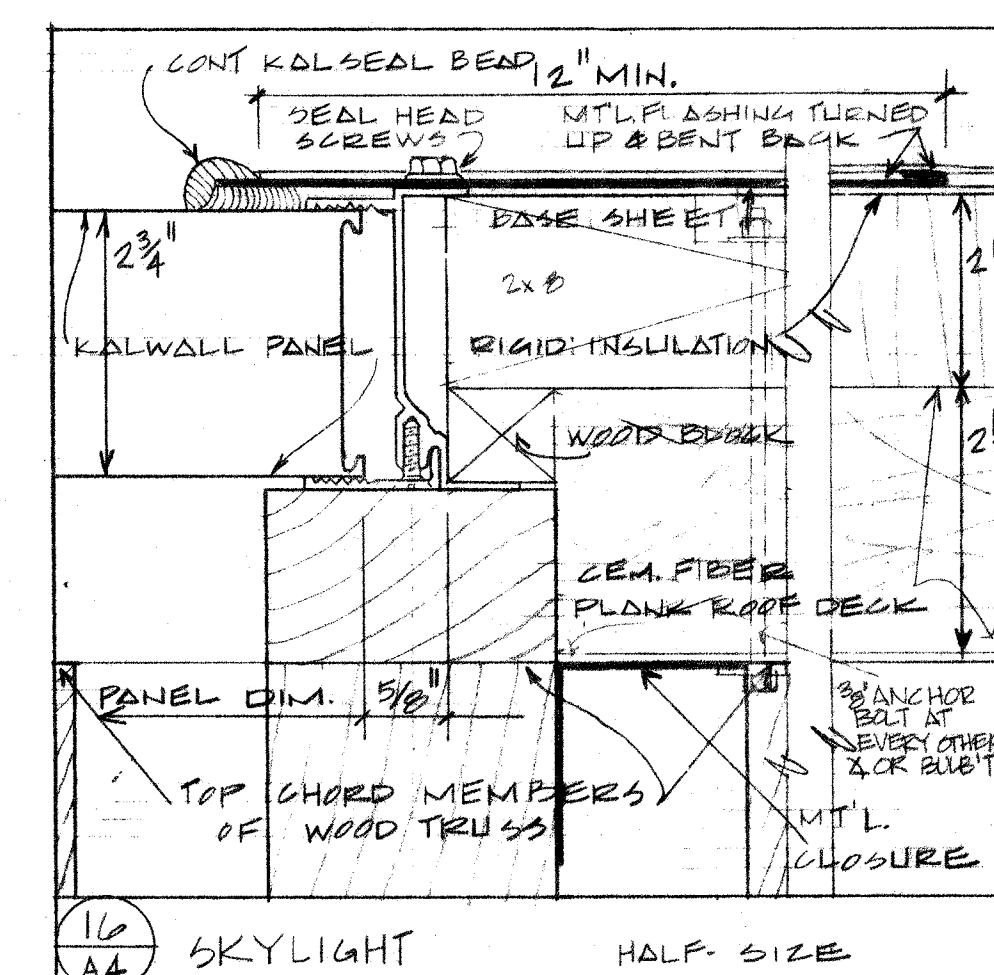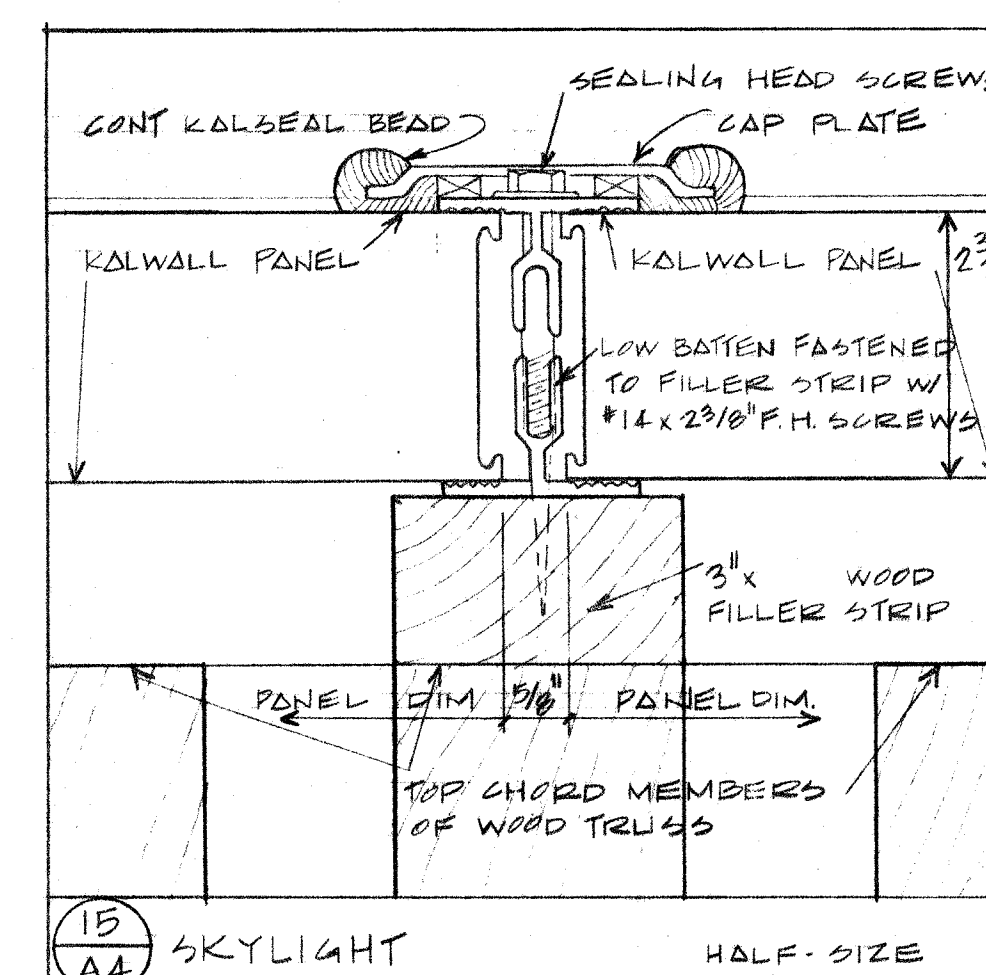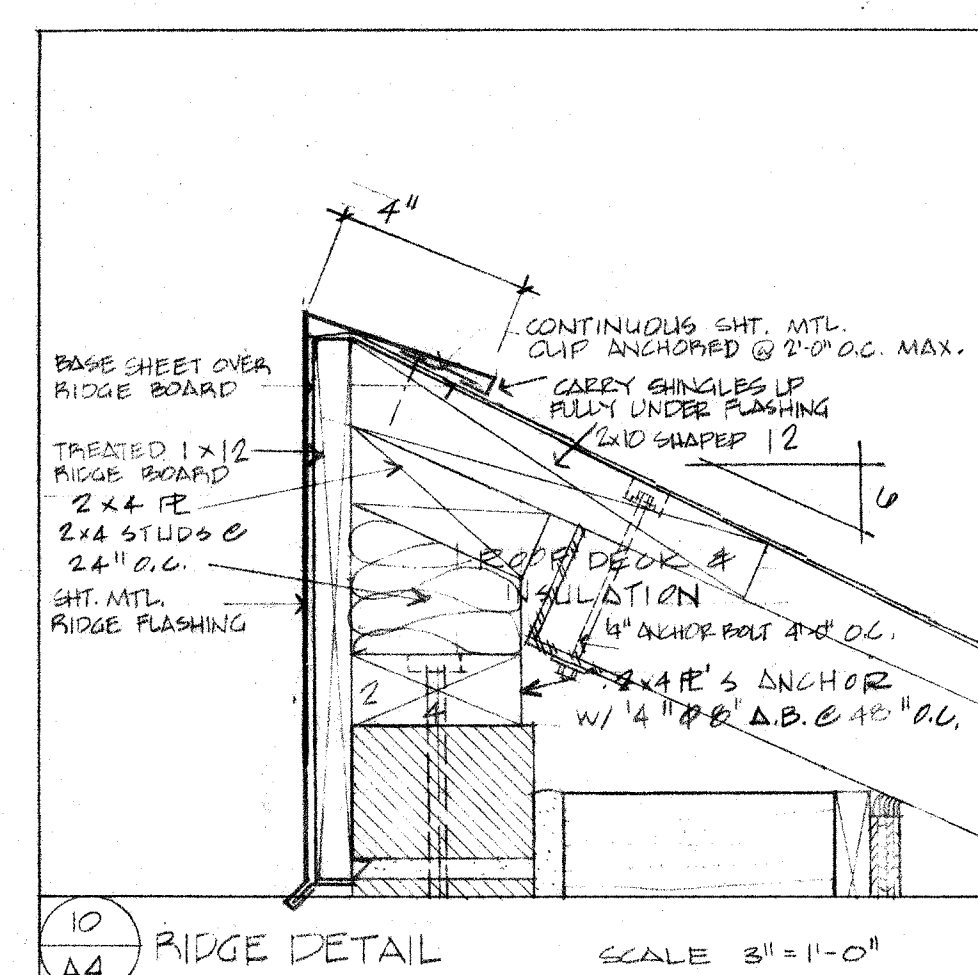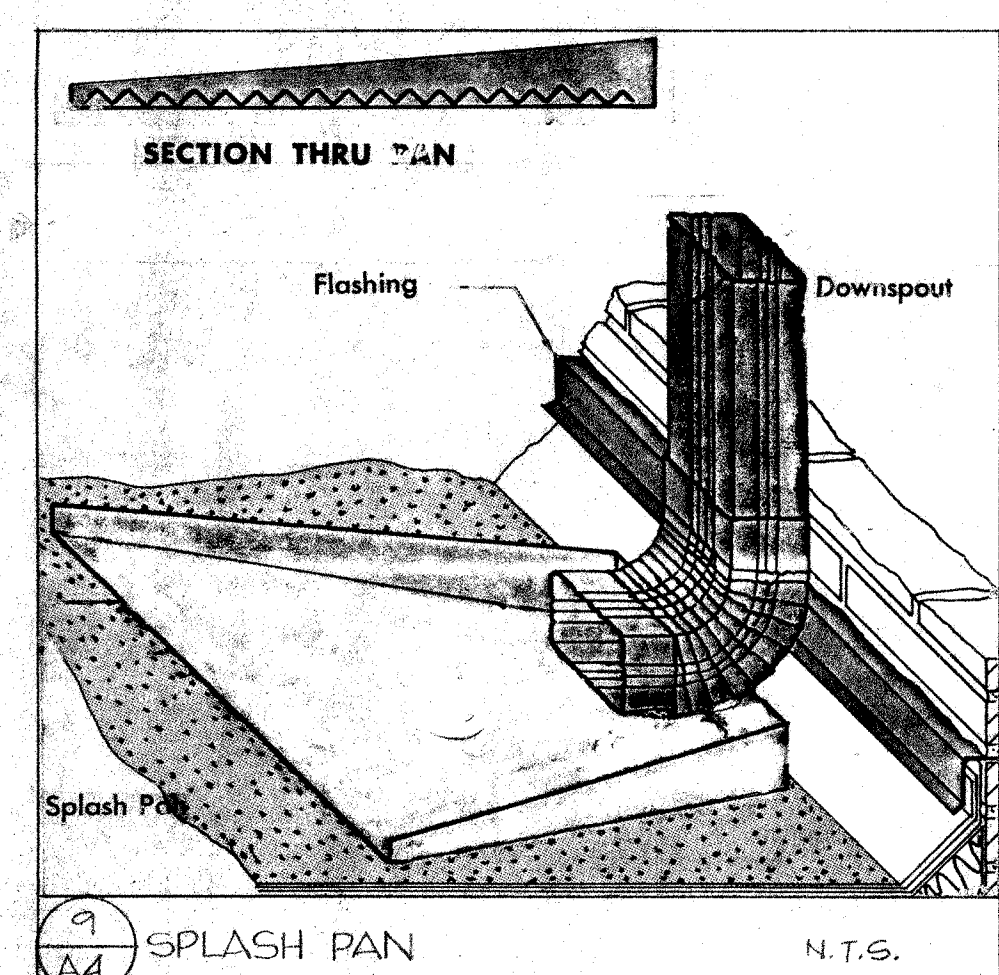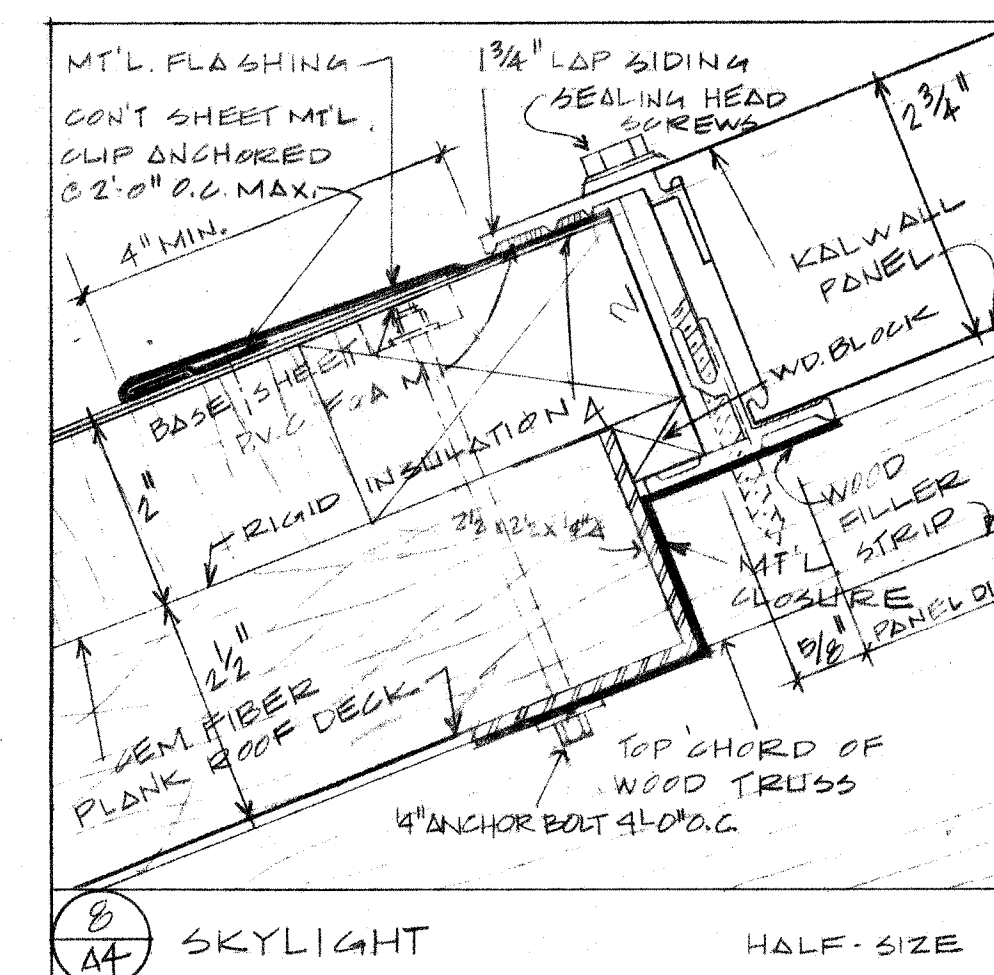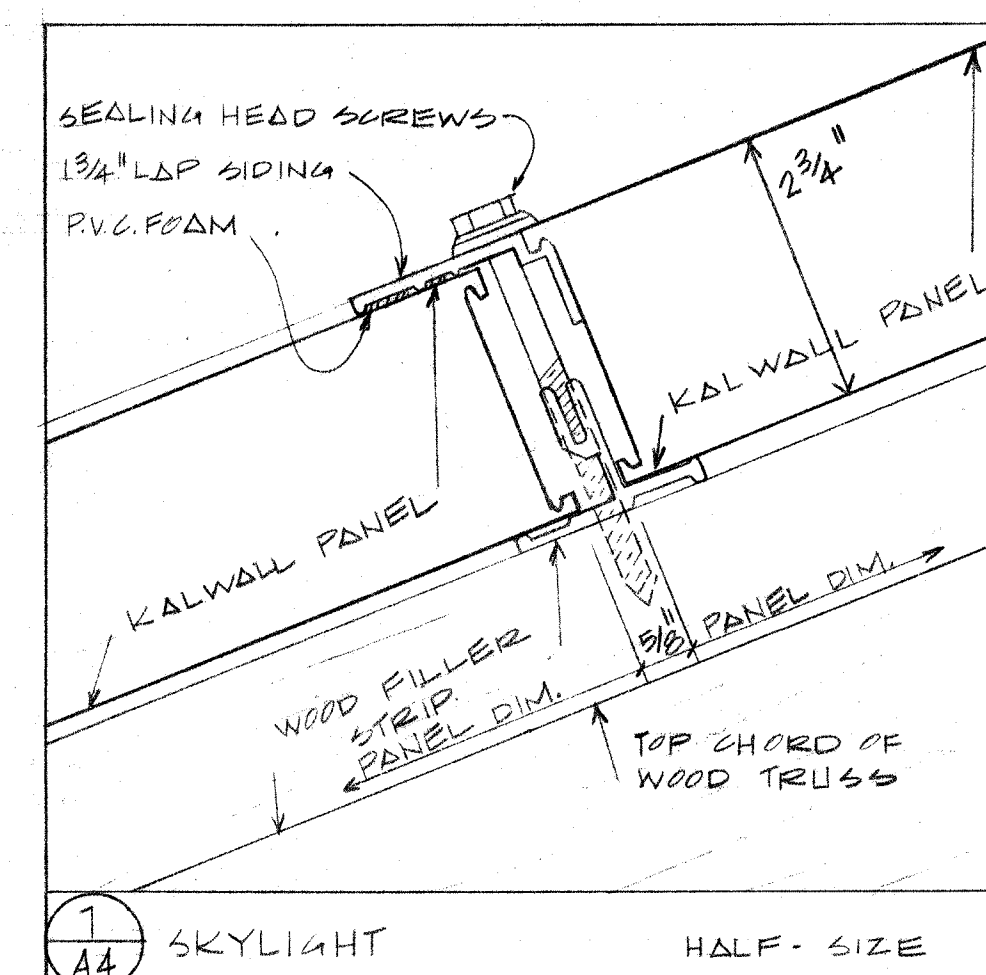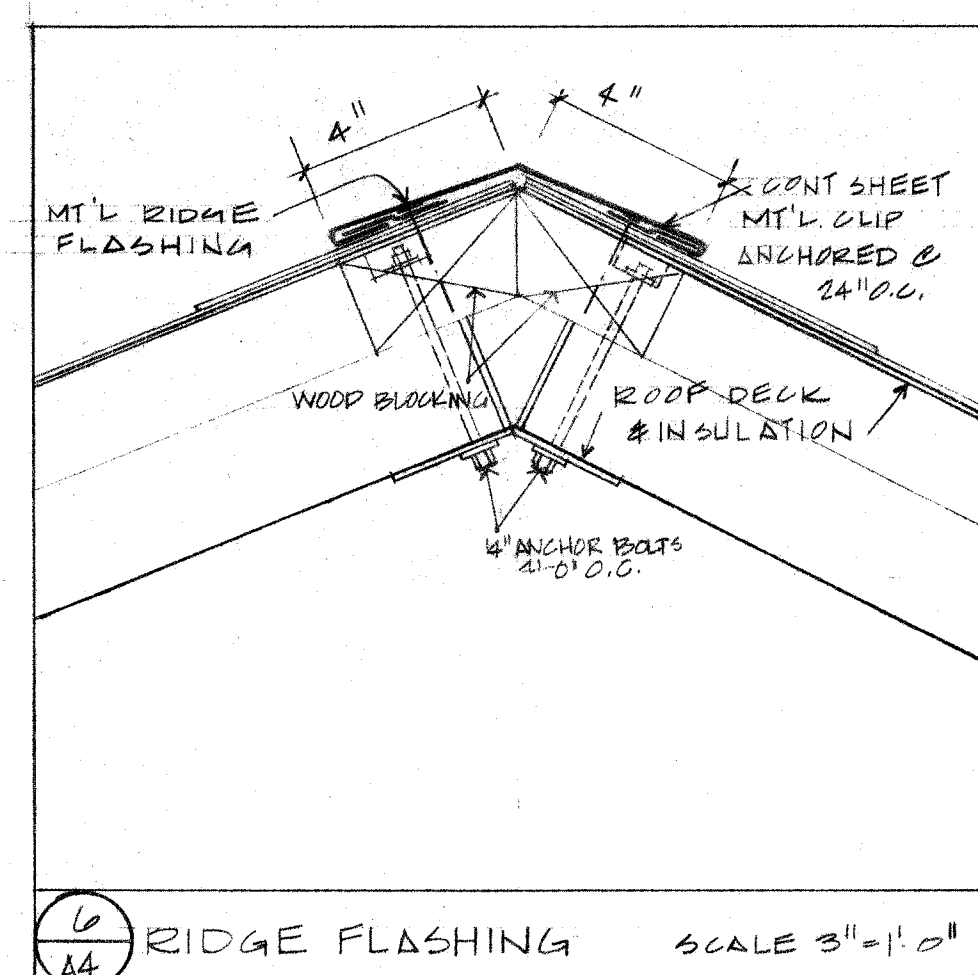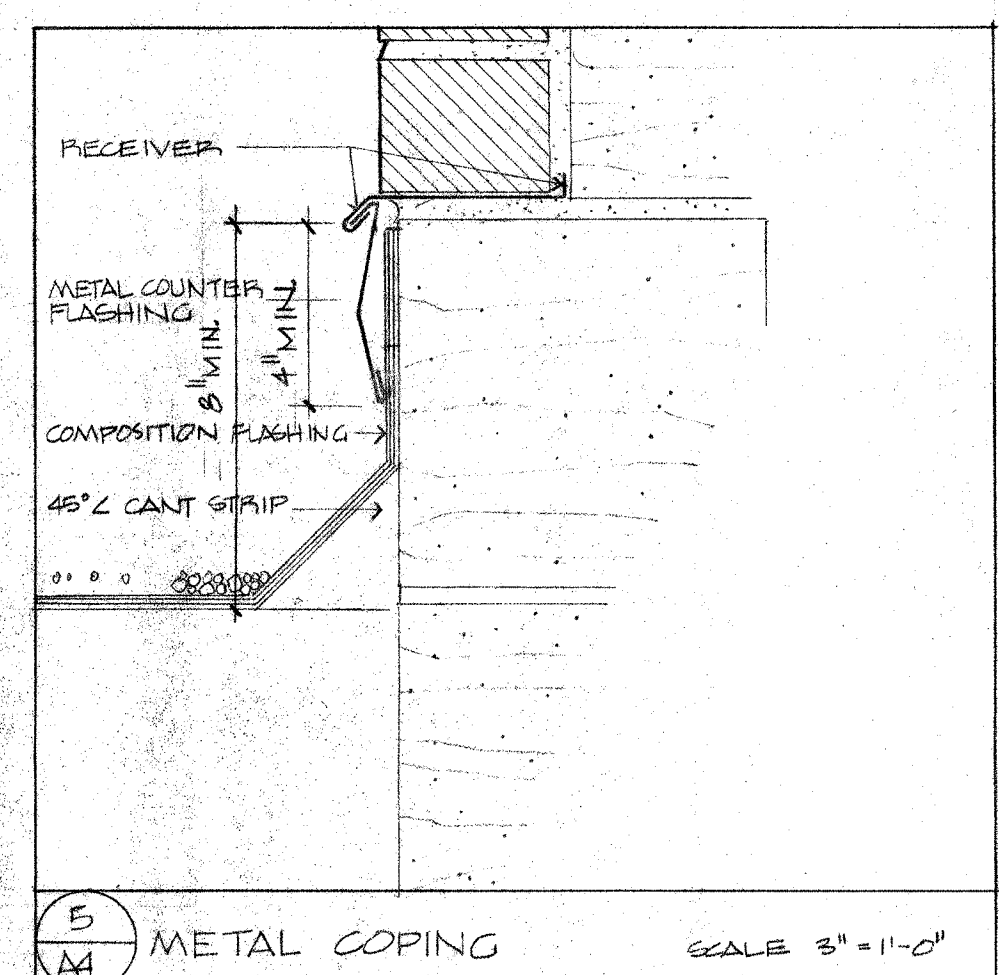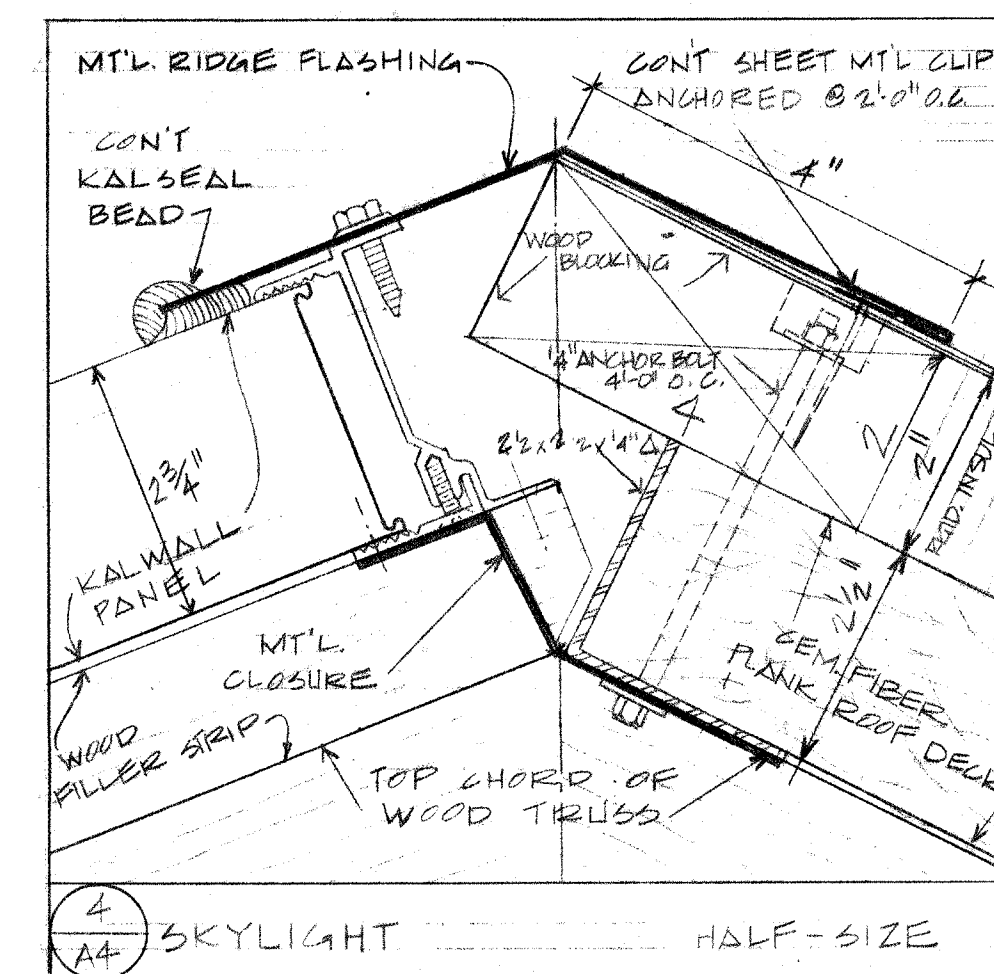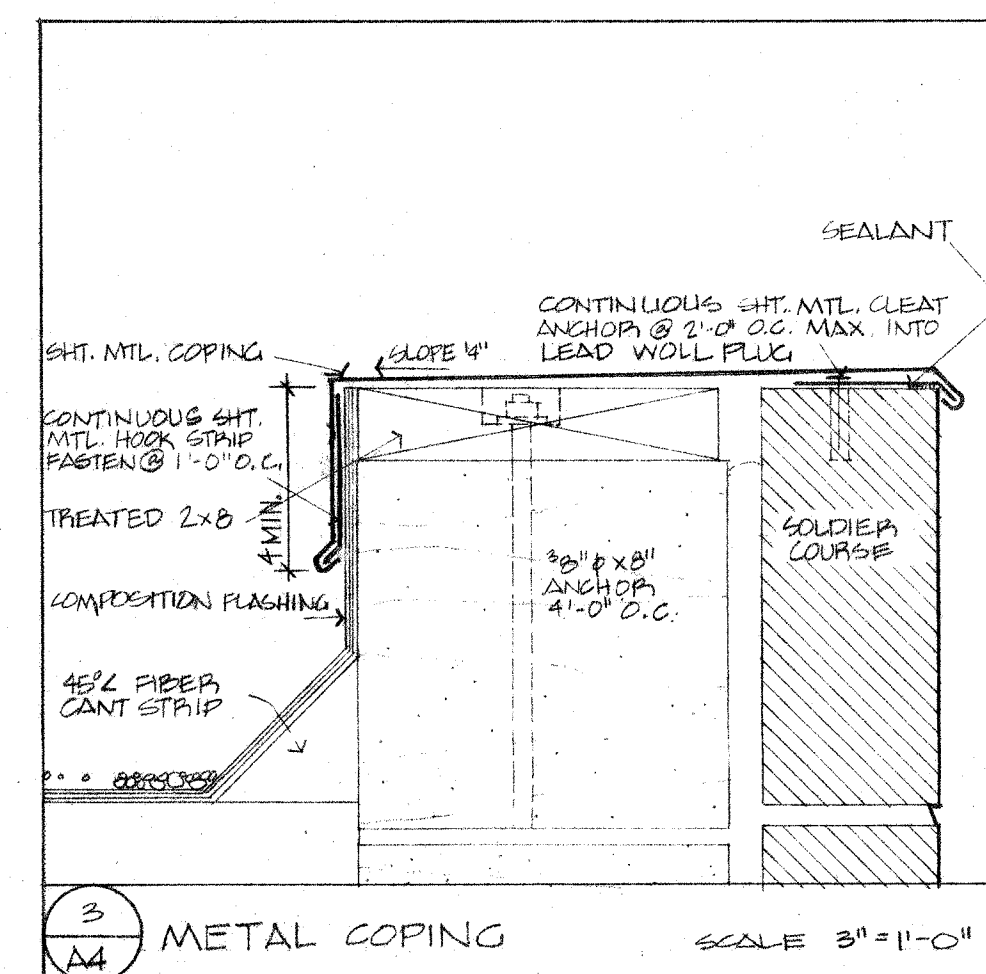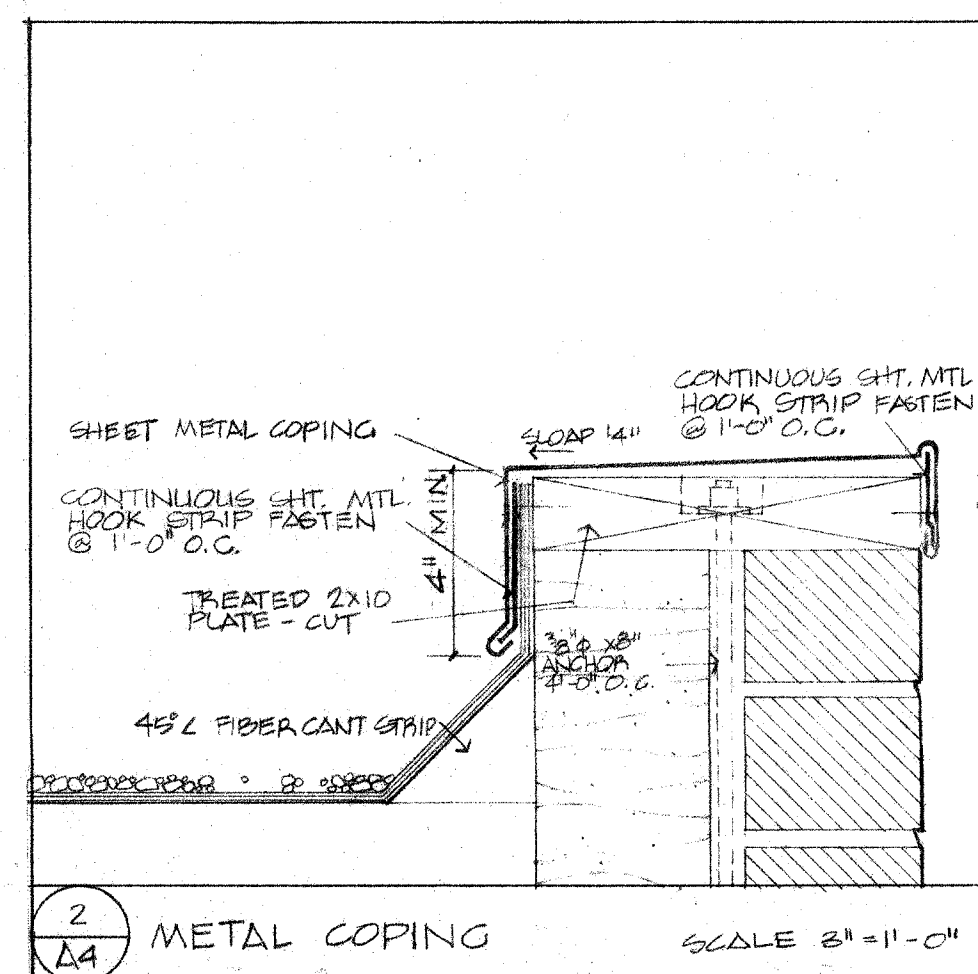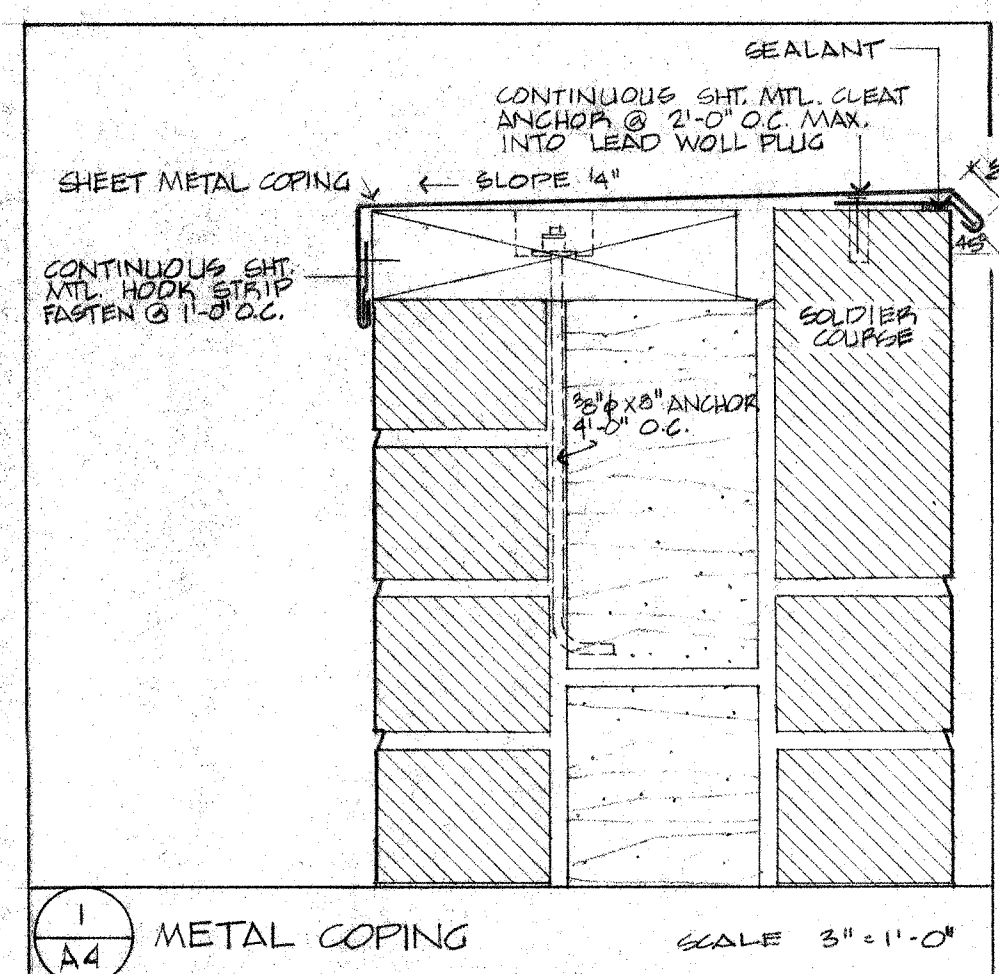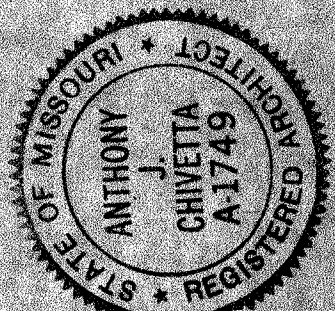


ROOF & LOWER LEVEL PLANS & DETAILS

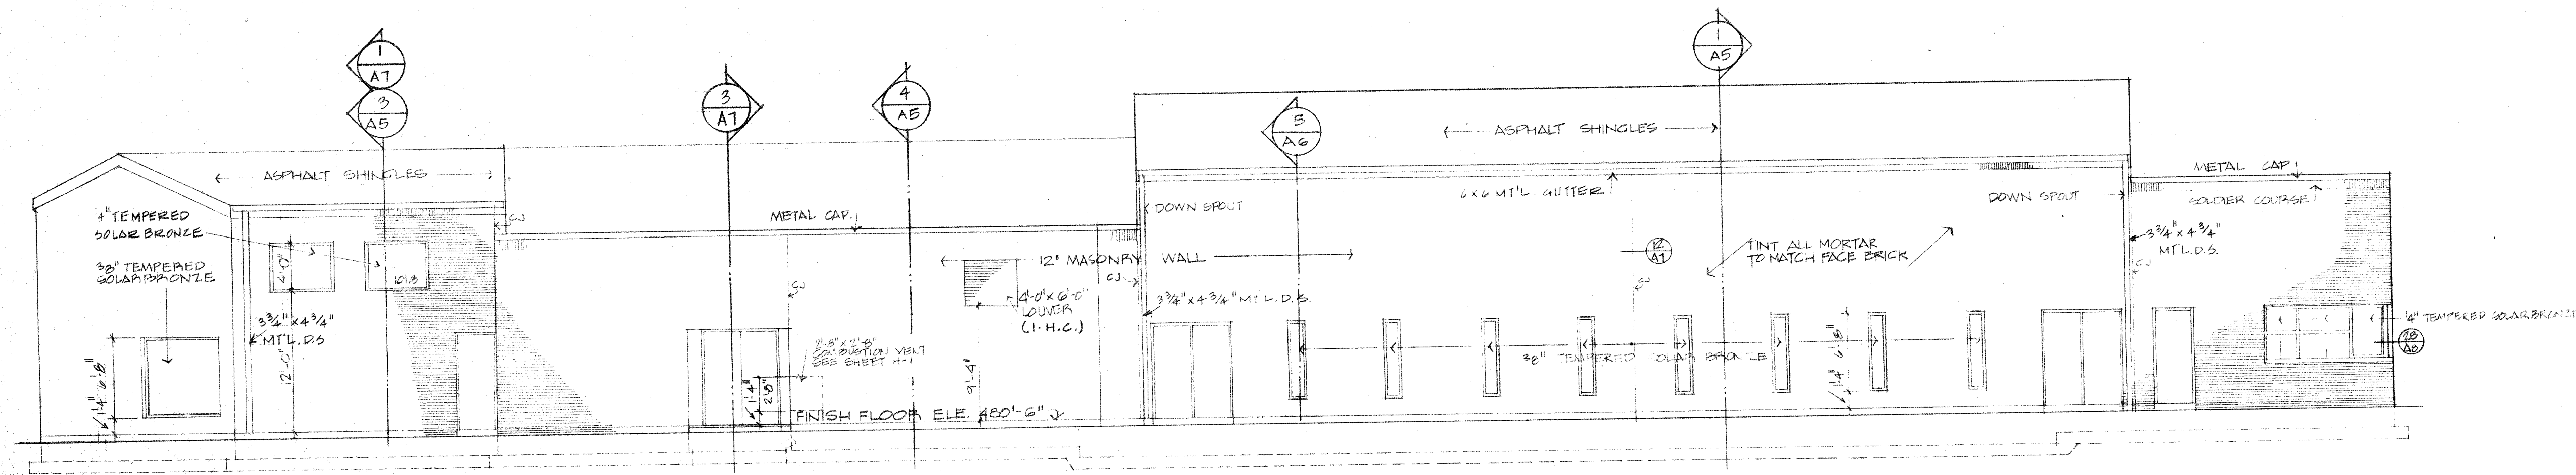


NORTH ELEVATION

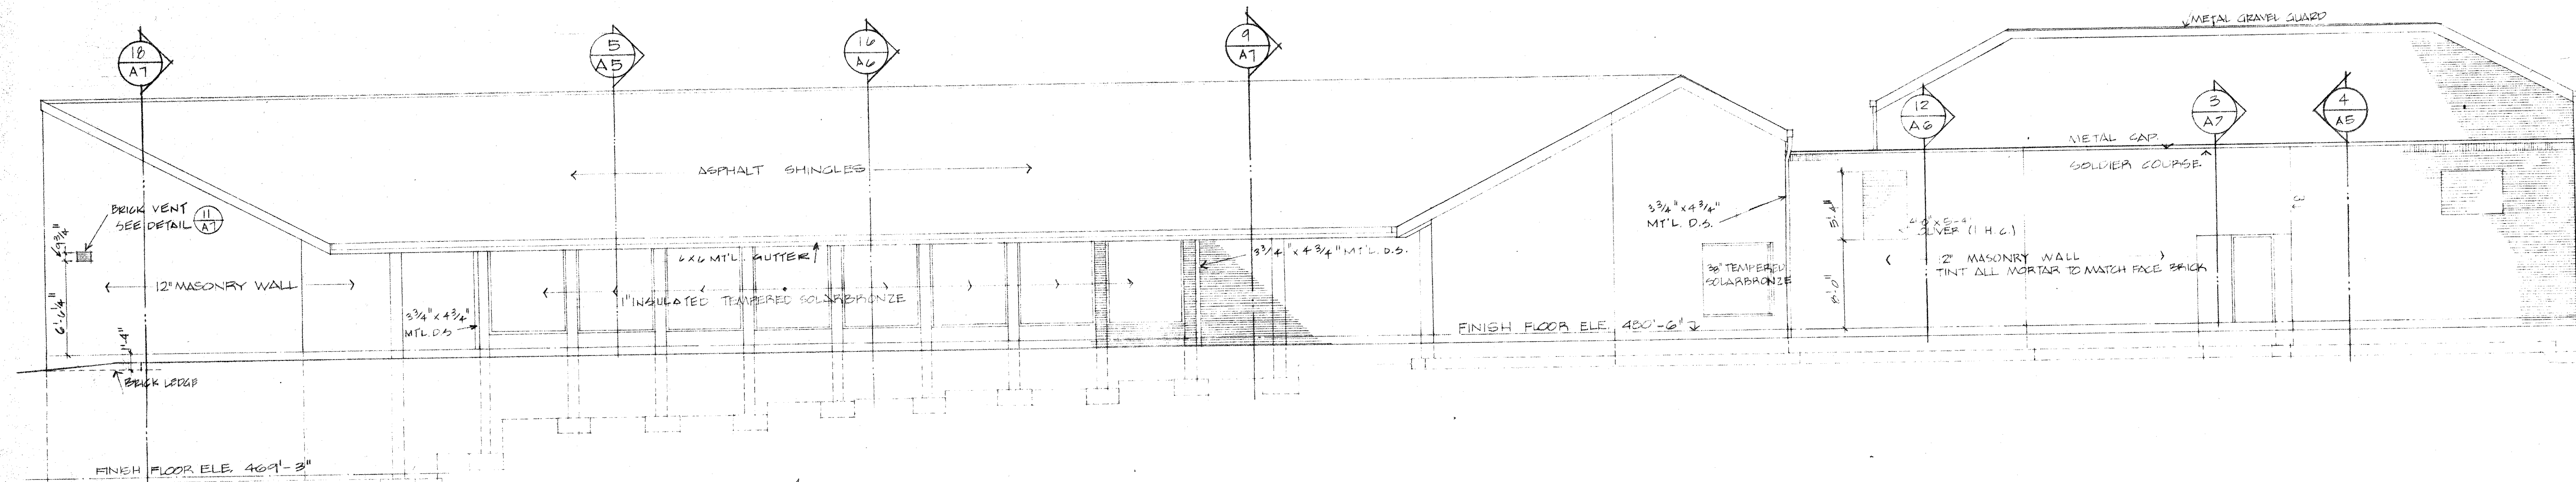


EAST ELEVATION

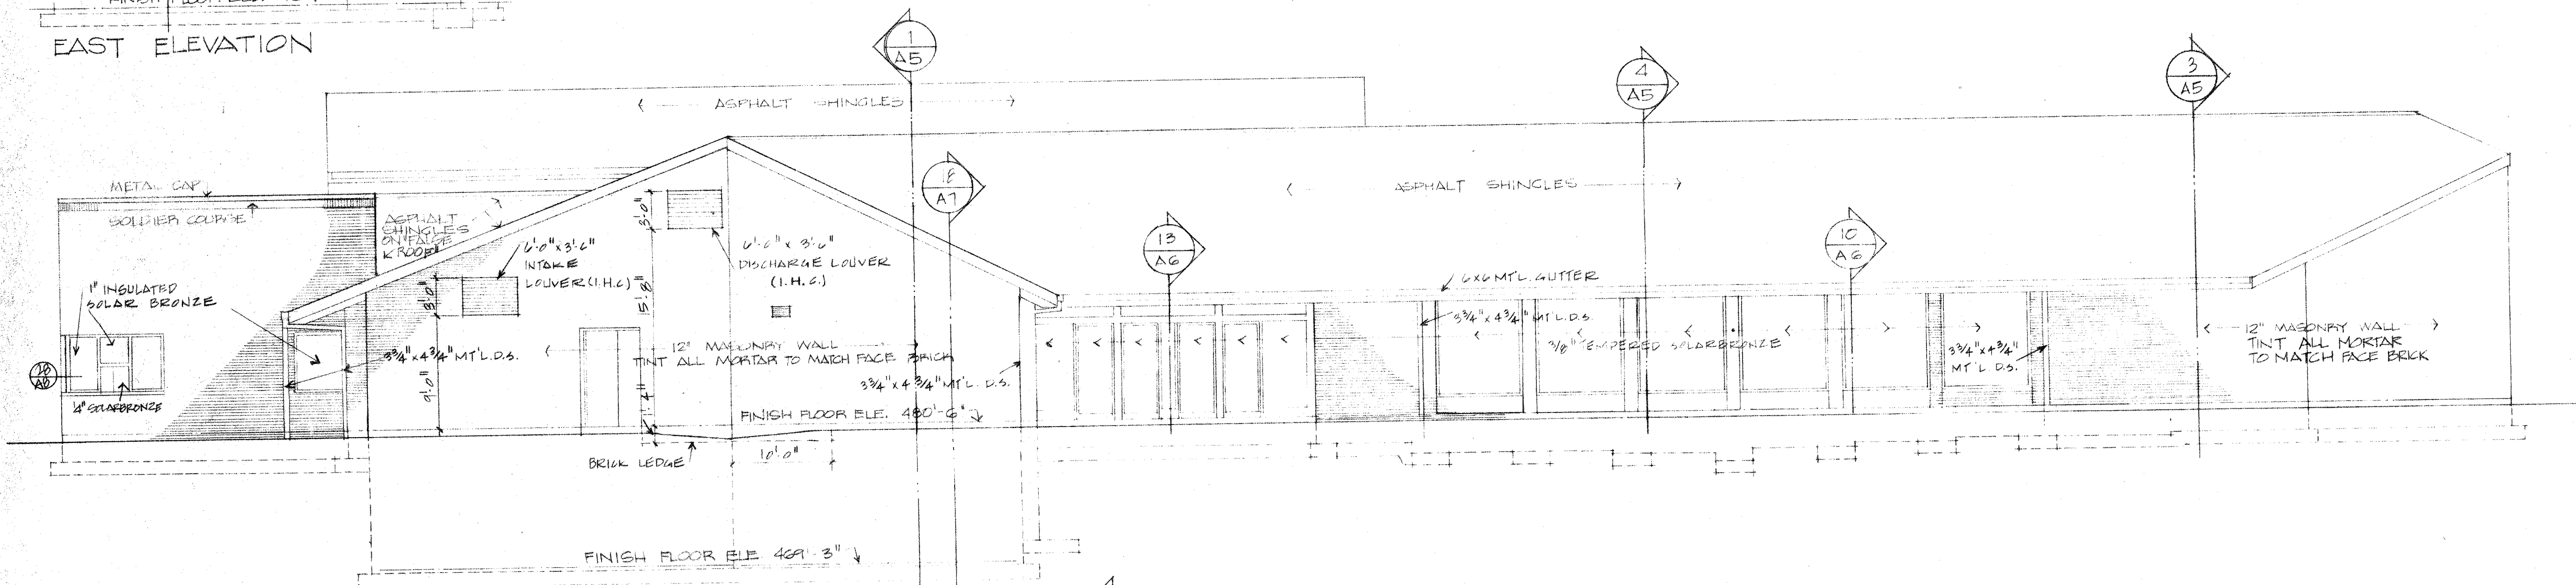


SOUTH ELEVATION

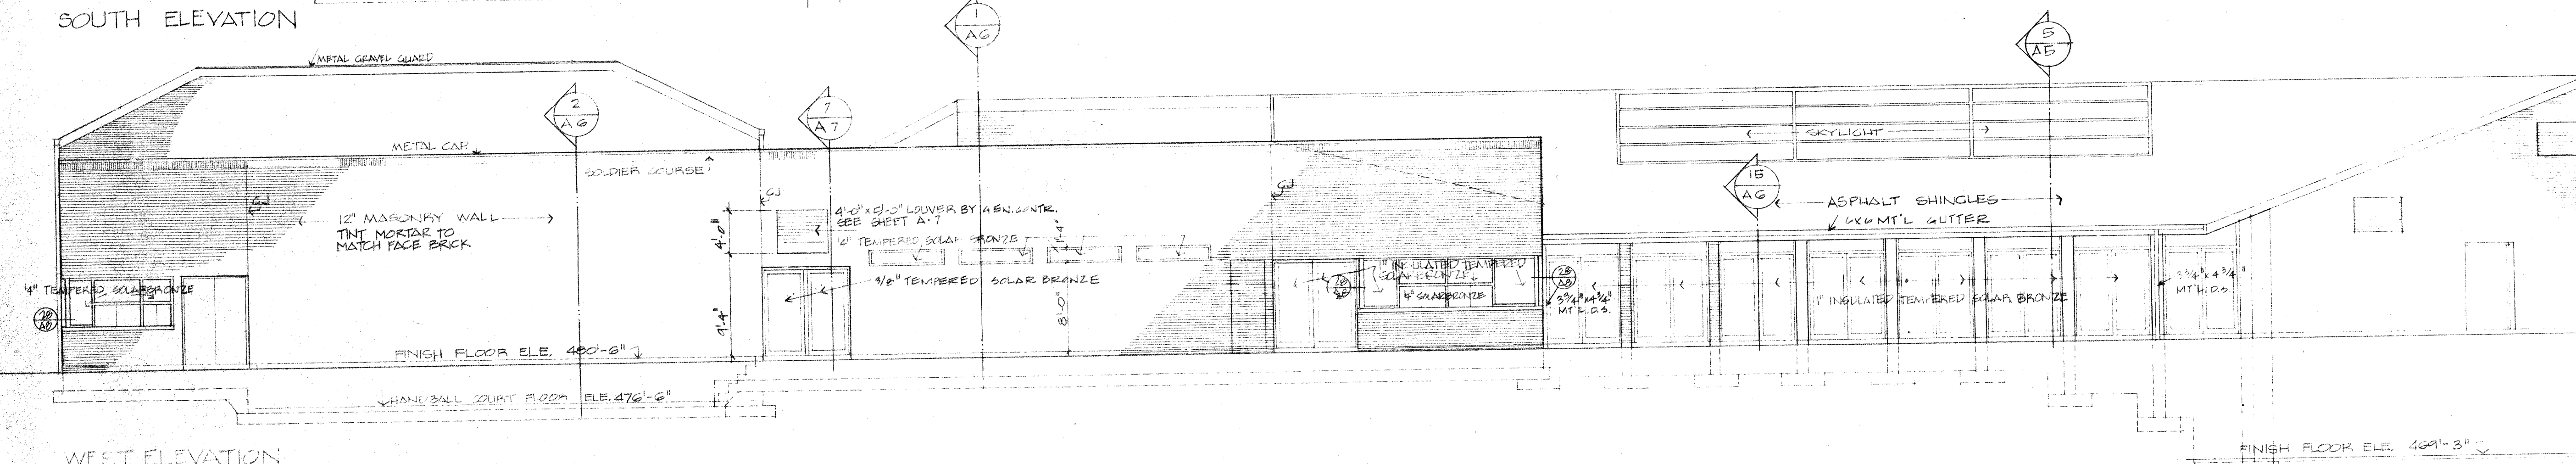


WEST ELEVATION

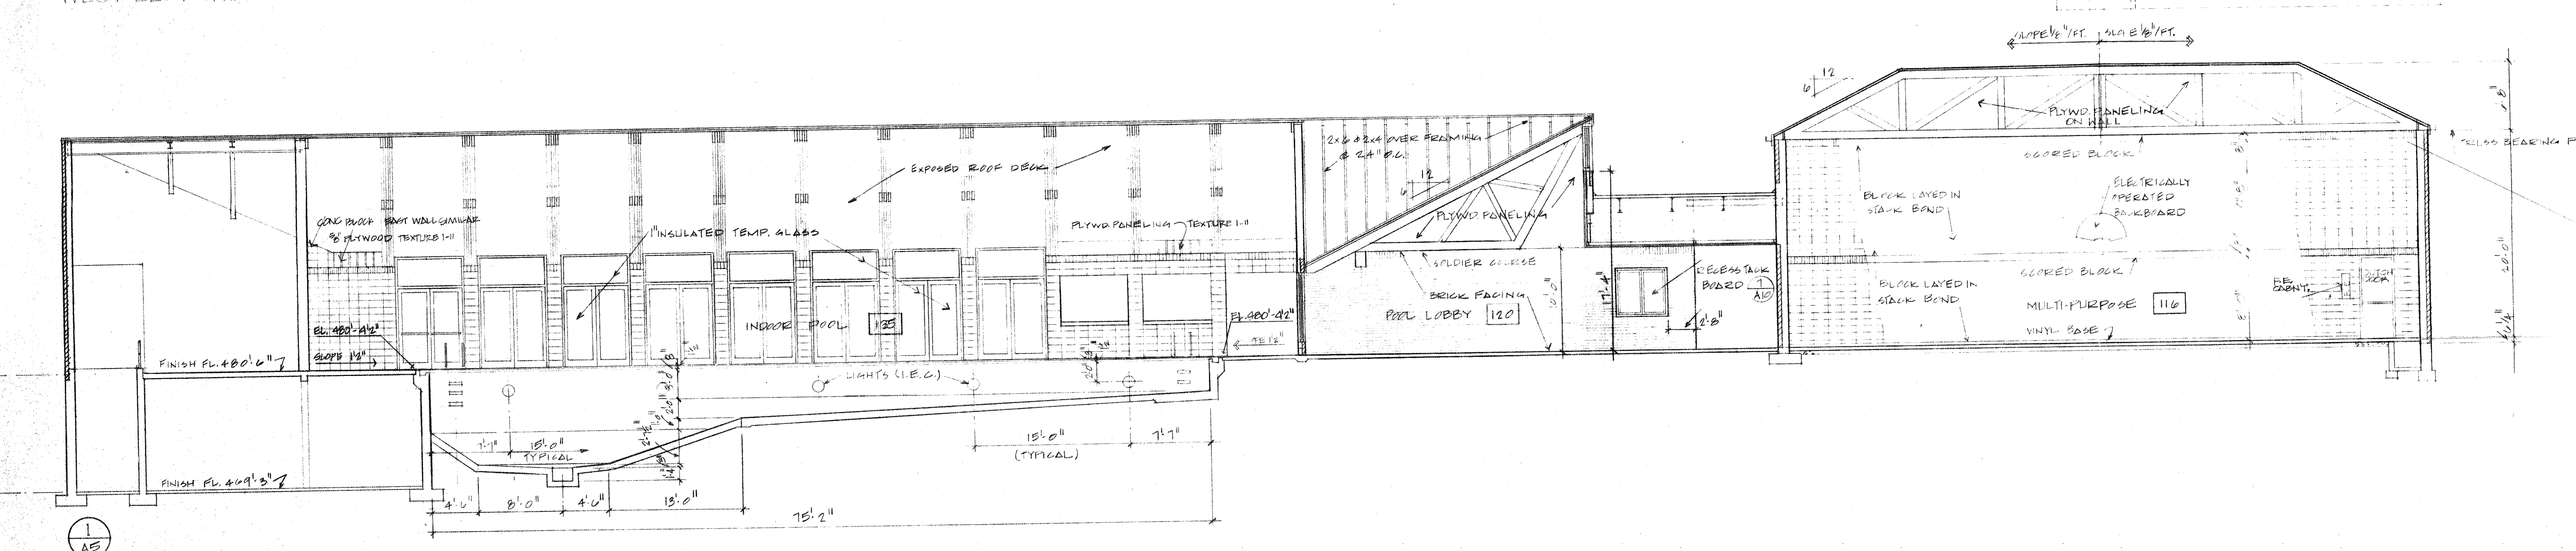


NOTE
SEE STRUCTURAL PLAN
FOR ALL EXTERIOR
OPENINGS LINTELS

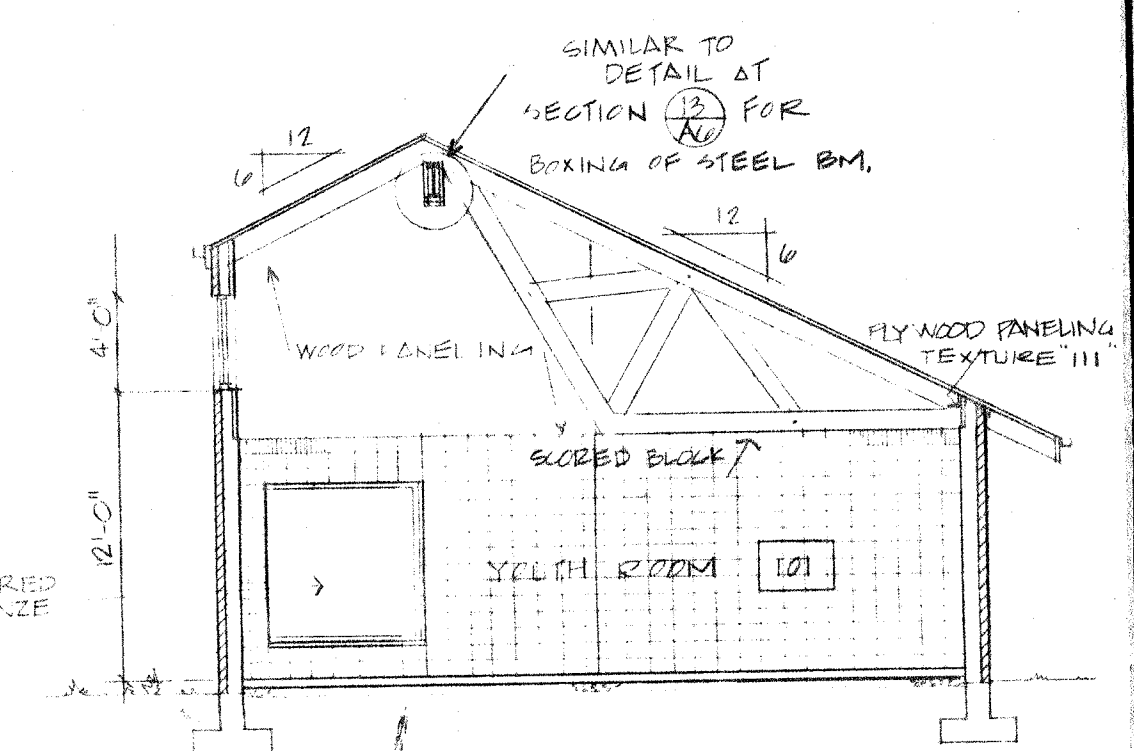

2 BUILDING SECTION

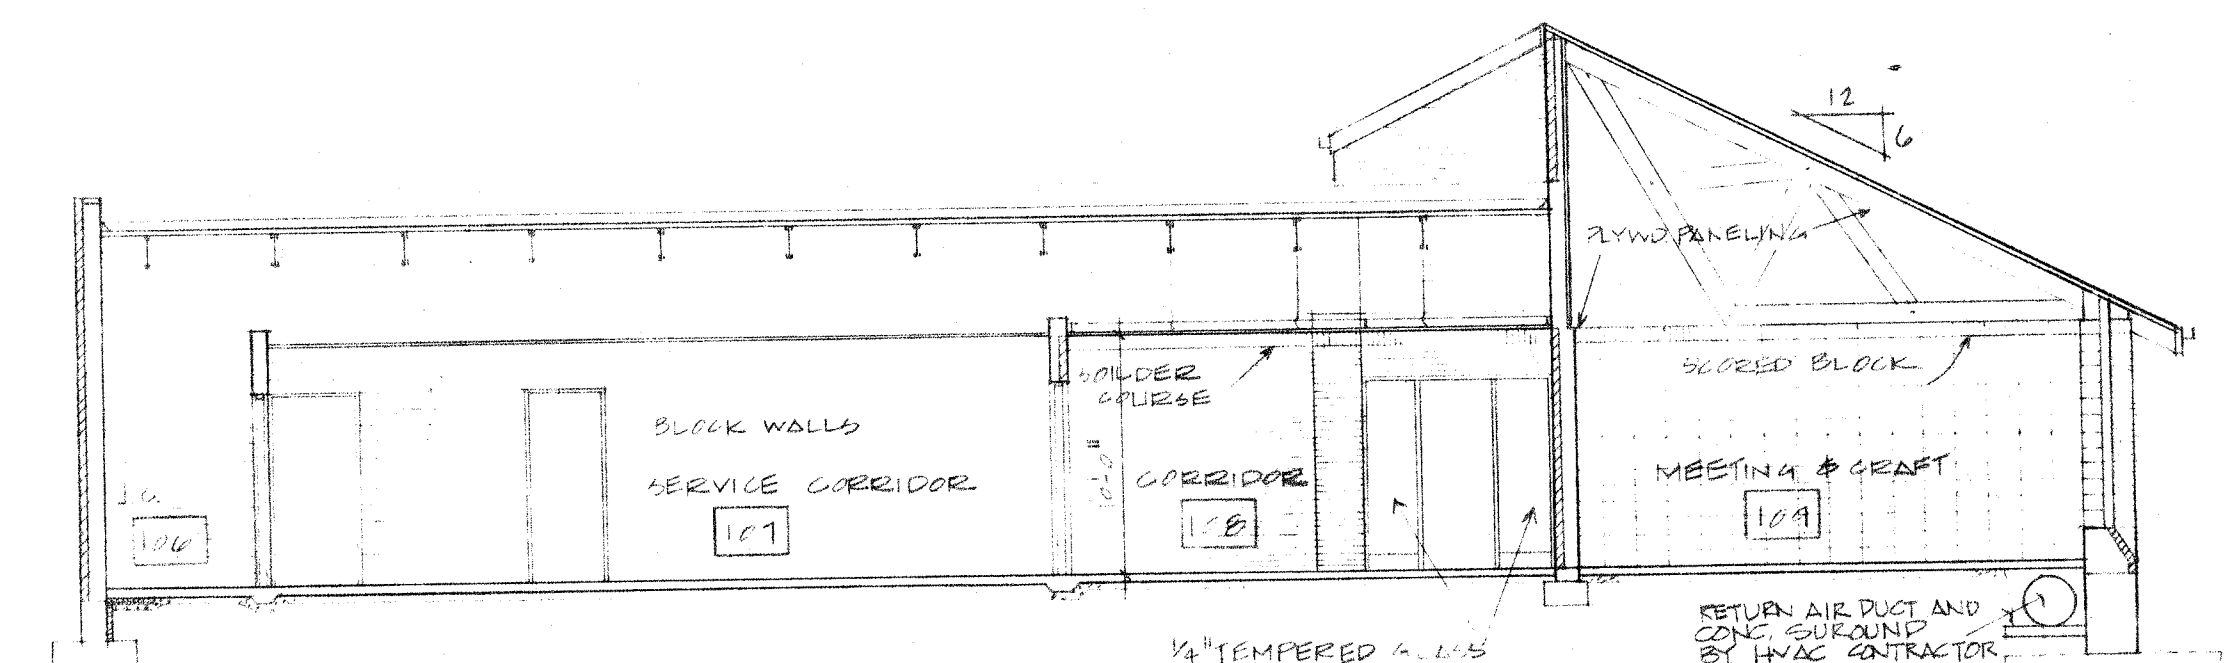


4 BUILDING SECTION

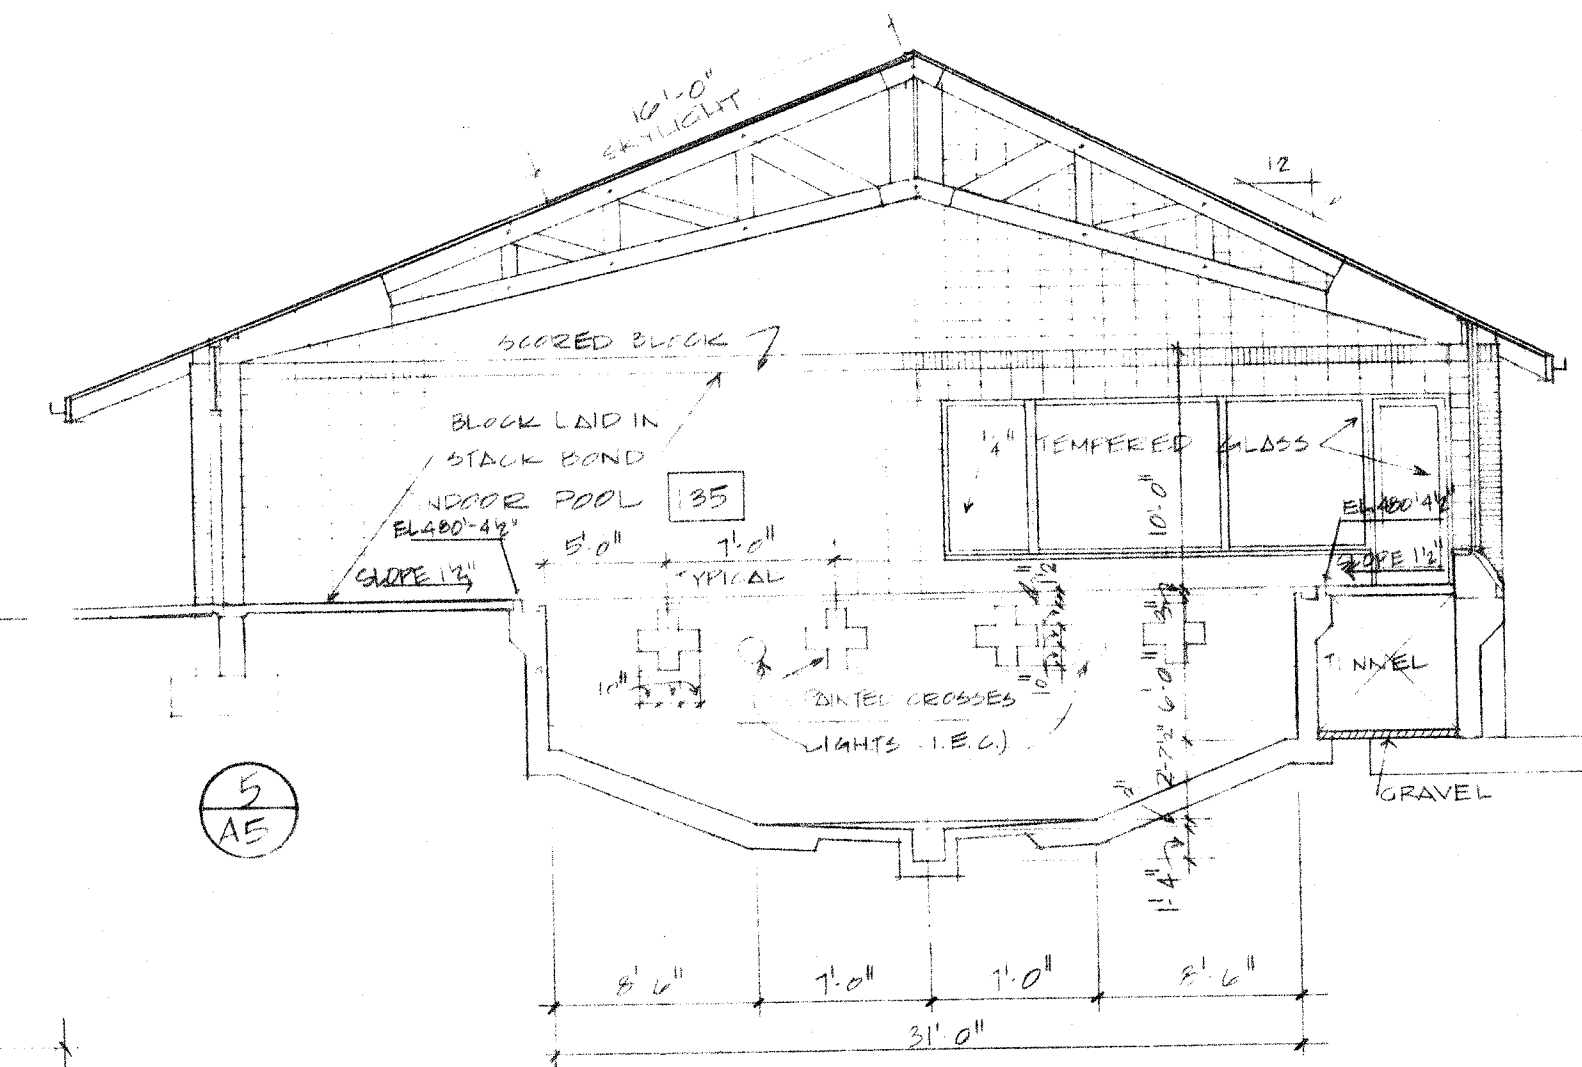

5 BUILDING SECTION

EXTERIOR ELEVATIONS &
BUILDING SECTIONS
SCALE 1/8" = 1'-0"

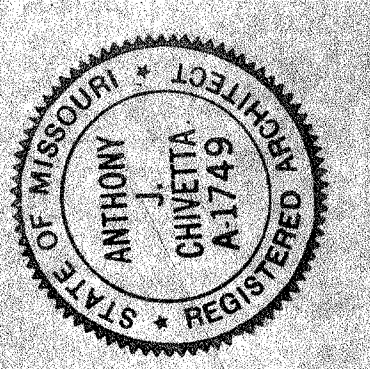

Hastings & Chivetta Architects


7733 Forsyth Boulevard, Clayton, Missouri 63105 314-863-5717
Frank A. Romano & Associates
Hansen Engineering
Henicke & Theiss

Bellefontaine Neighbors
Community Center


MAYOR RAYMOND ZIELINSKI

Job No. 1185
Date: 04/15/14
Revisions:


A5

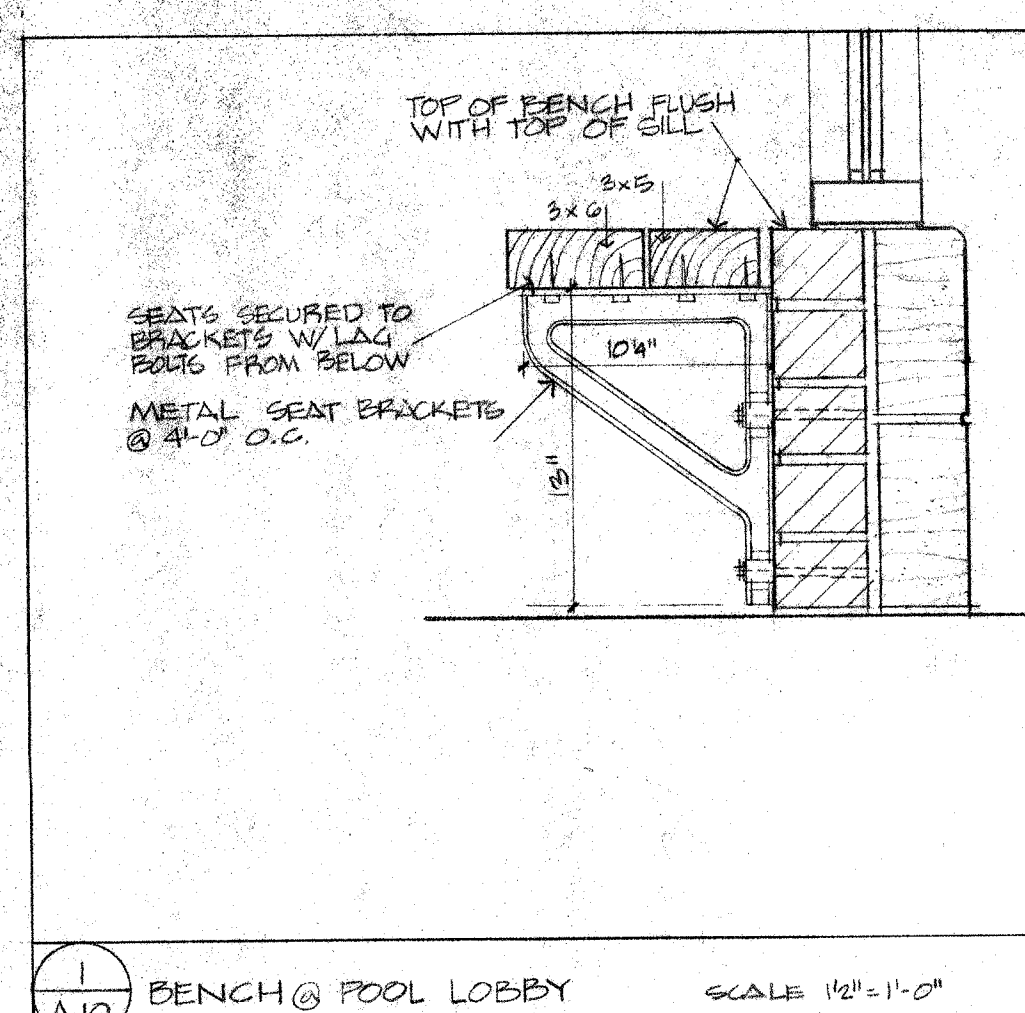


1 A10 BENCH @ POOL LOBBY SCALE 1/2\"/>

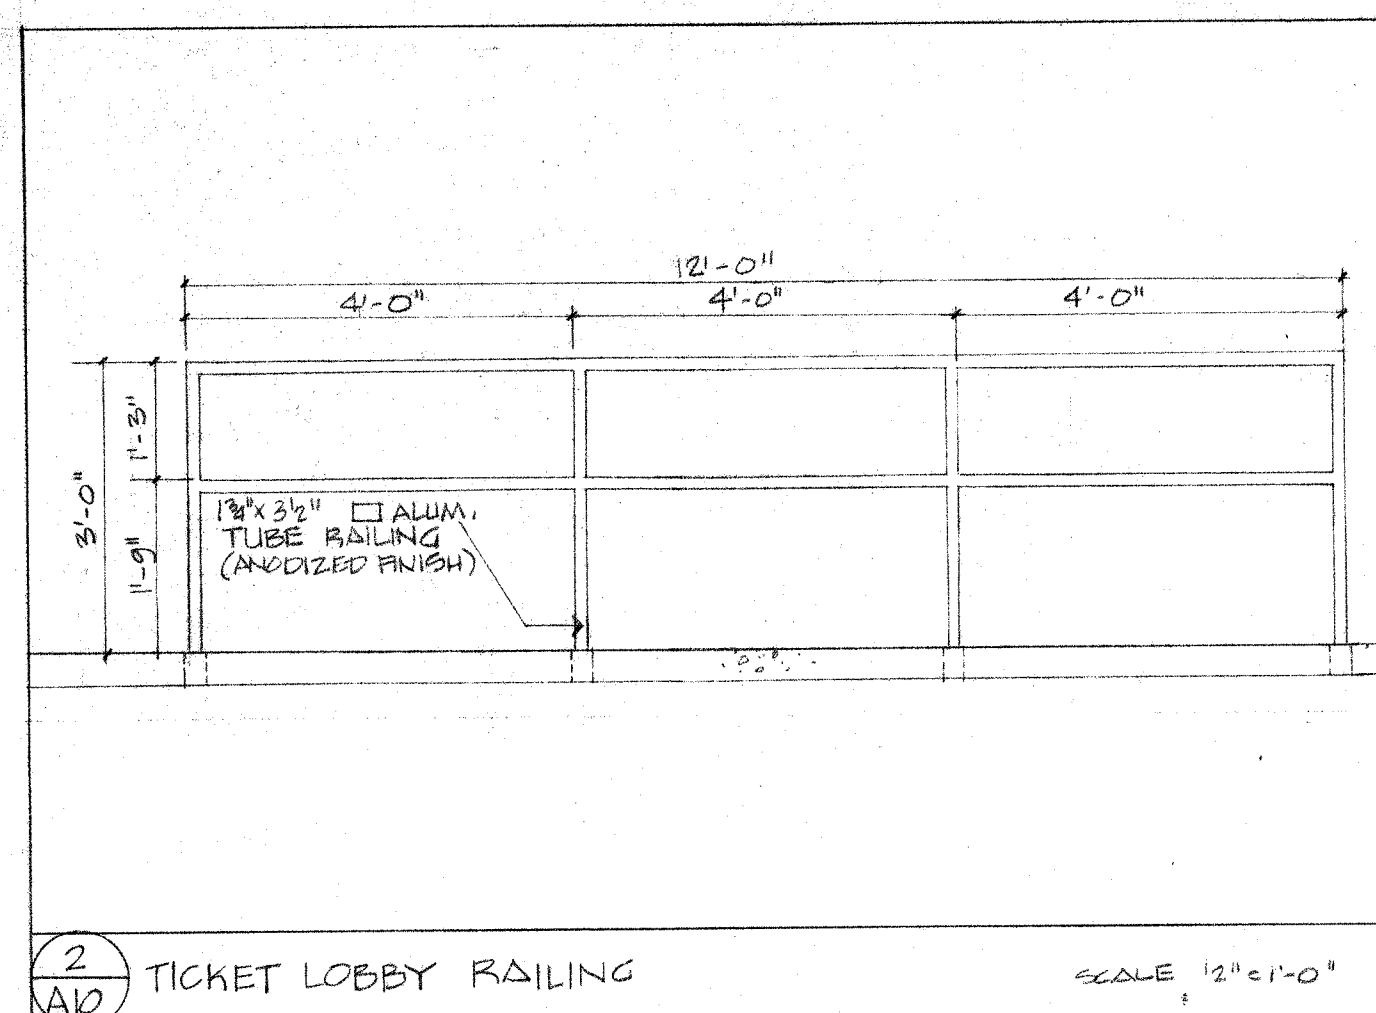


2 A10 TICKET LOBBY RAILING SCALE 1/2\"/>

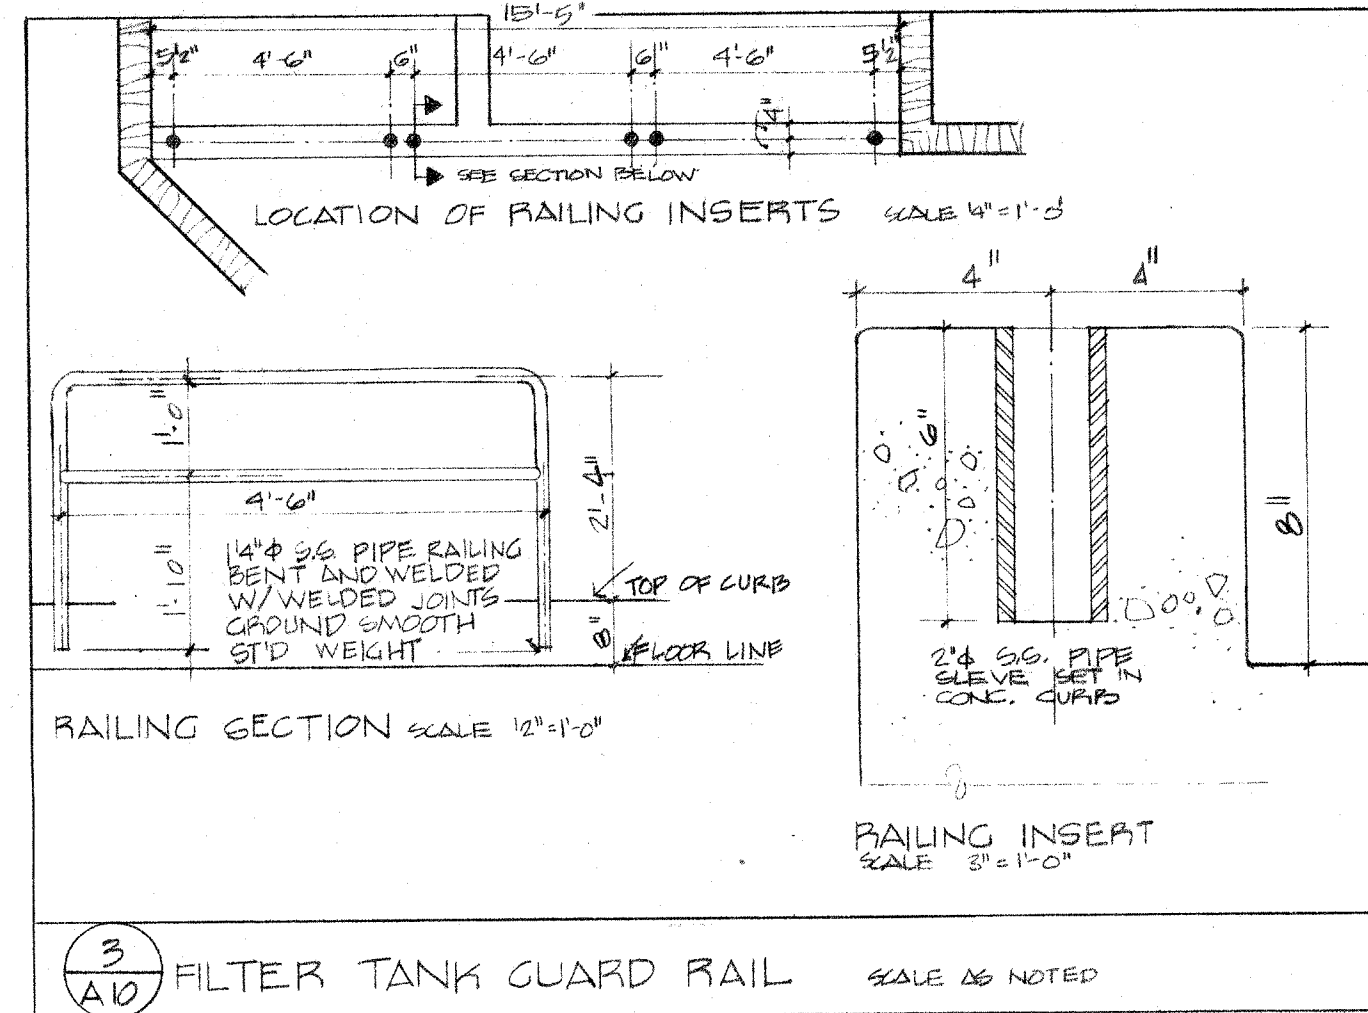


3 A10 FILTER TANK GUARD RAIL SCALE AS NOTED

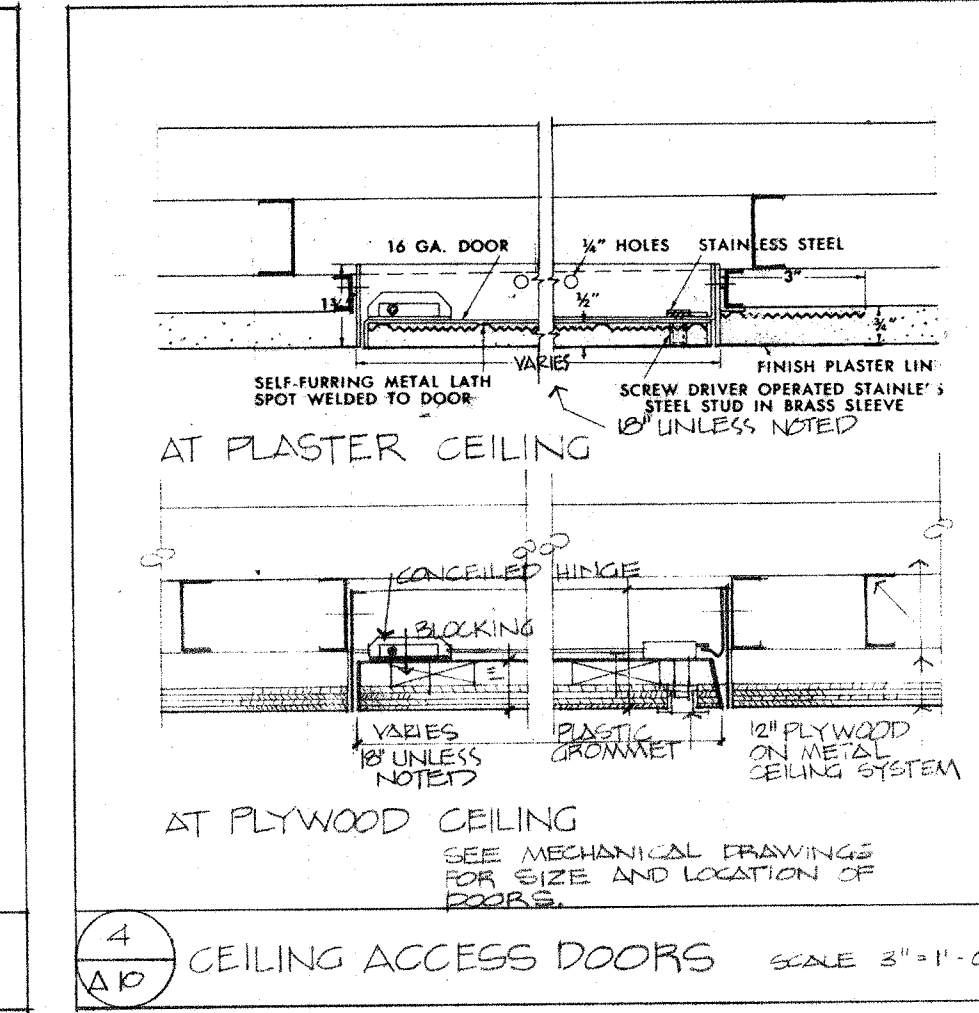


4 A10 CEILING ACCESS DOORS SCALE 3/4\"/>

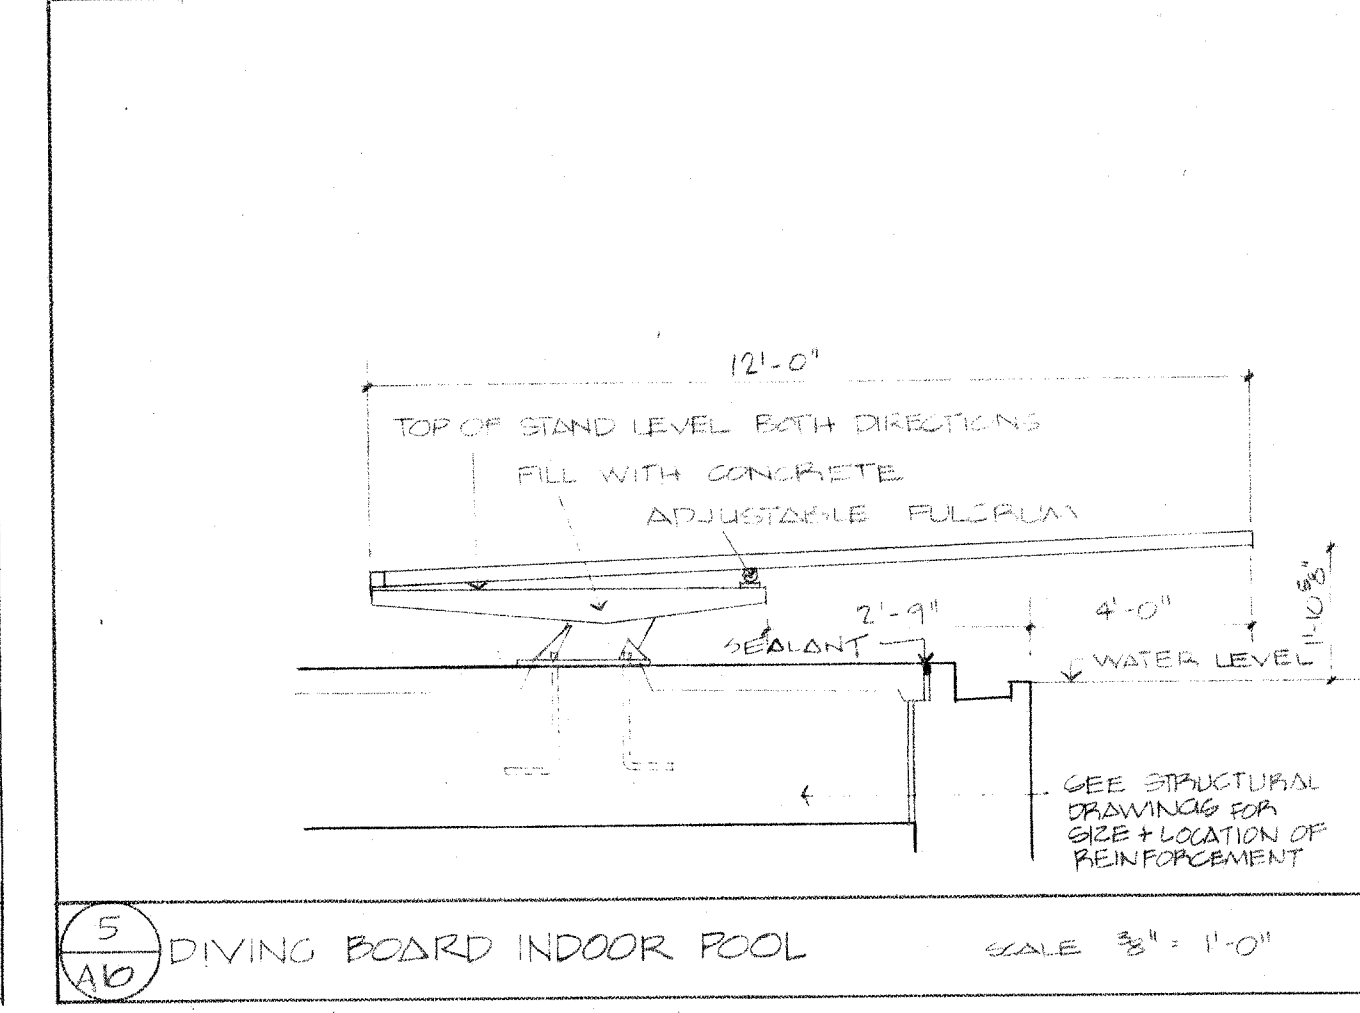


5 A10 DIVING BOARD INDOOR POOL SCALE 3/8\"/>

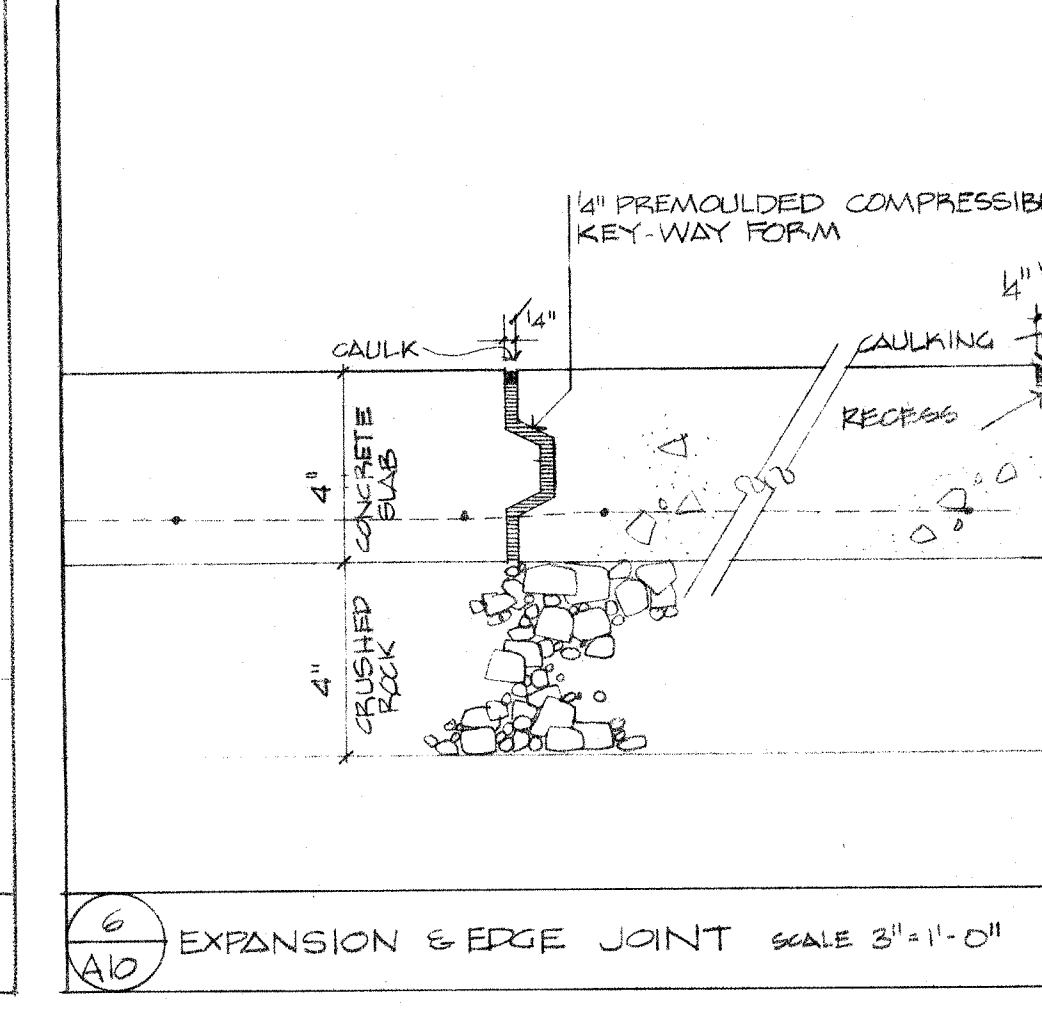


6 A10 EXPANSION & EDGE JOINT SCALE 3/4\"/>

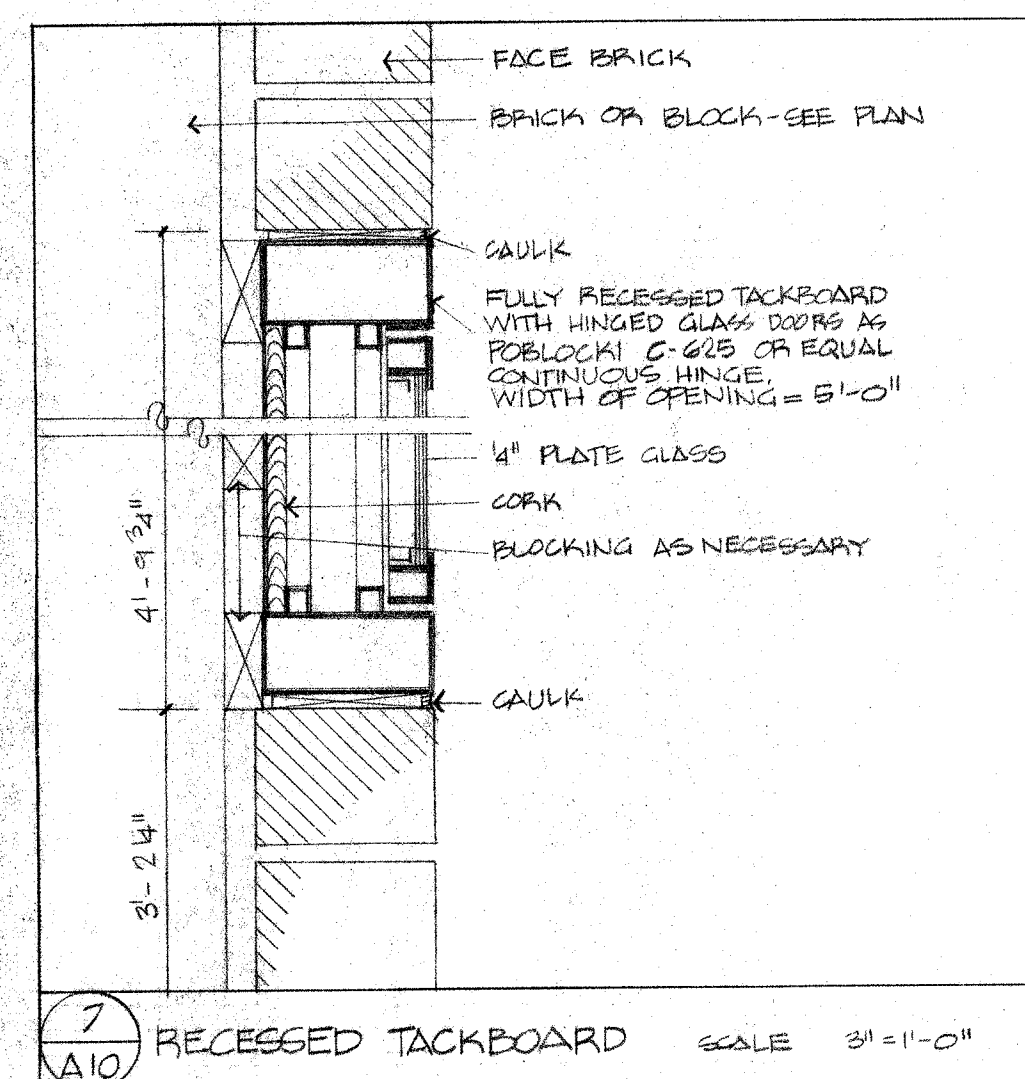


7 A10 RECESSED TACKBOARD SCALE 3/4\"/>

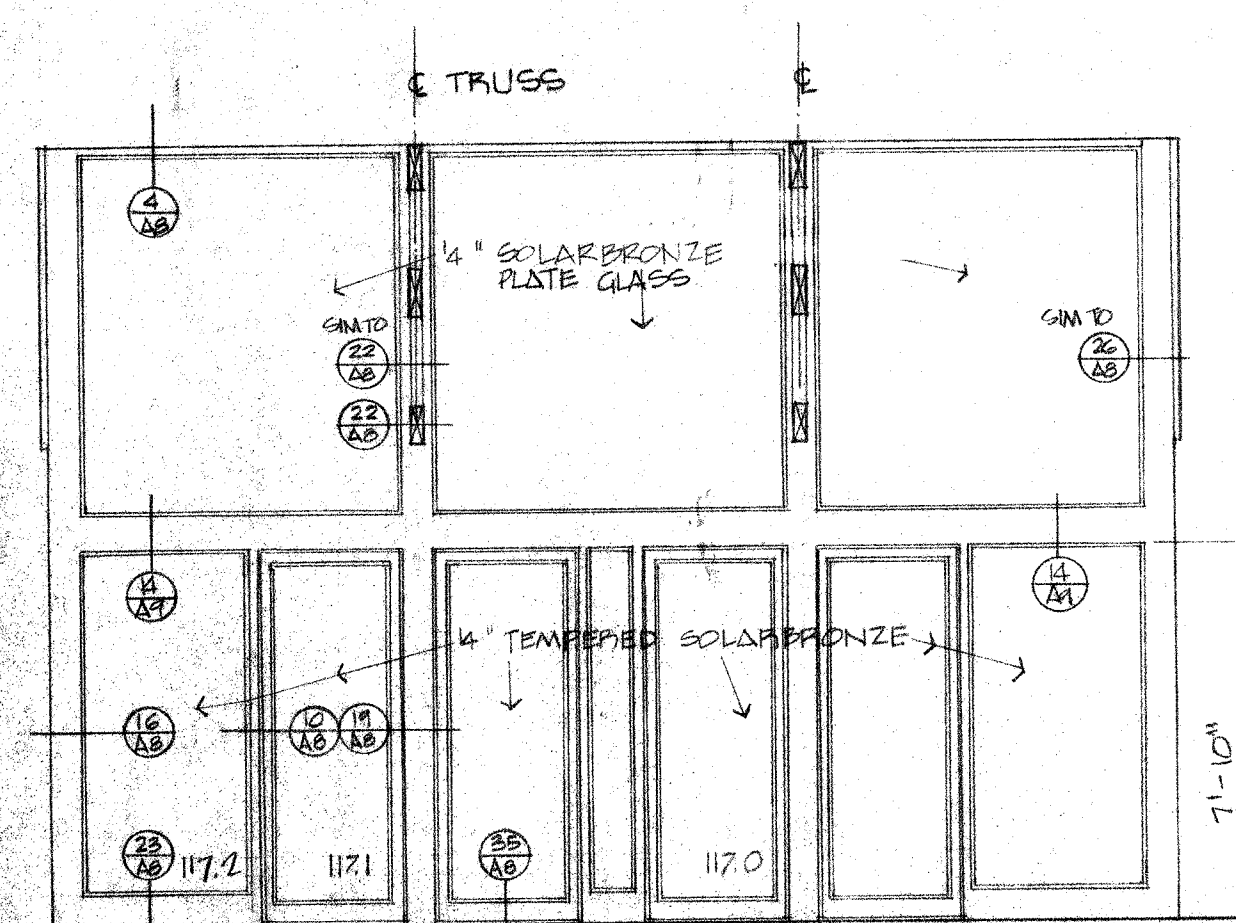


9 A10 ENTRY ELEVATION DOORS 117.0 117.1 117.2 SCALE 1/4\"/>

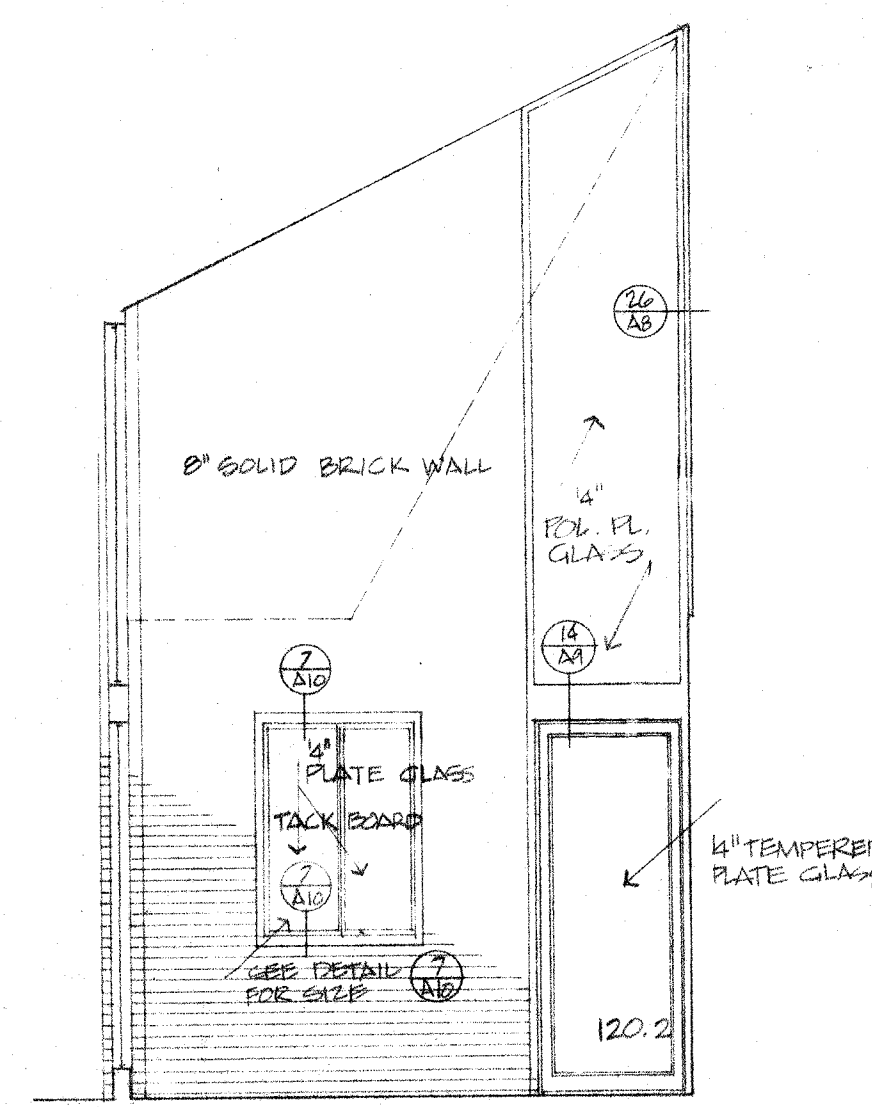


10 A10 DOOR 120.2 SCALE 1/4\"/>

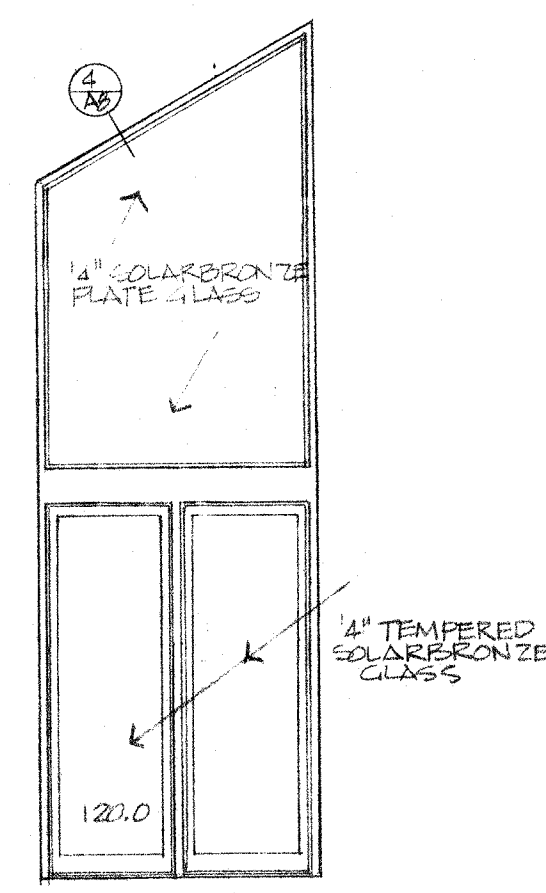


11 A10 DOOR 120.3 SCALE 1/4\"/>

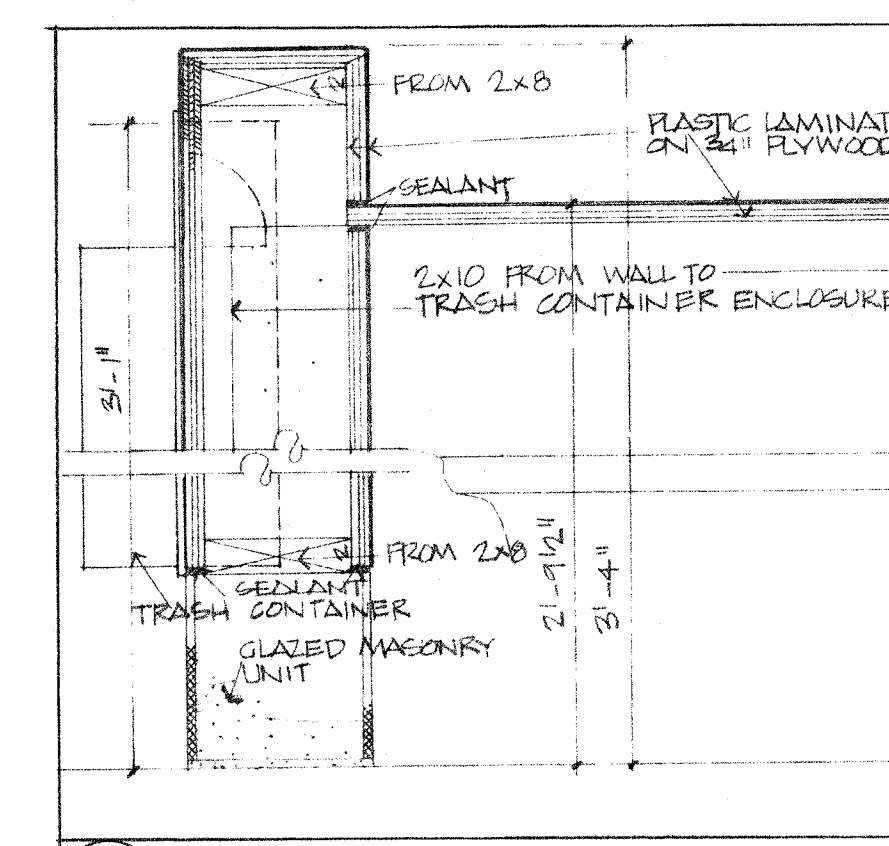


12 A10 TRASH CONTAINER ENCLOSURE SCALE 1/2\"/>

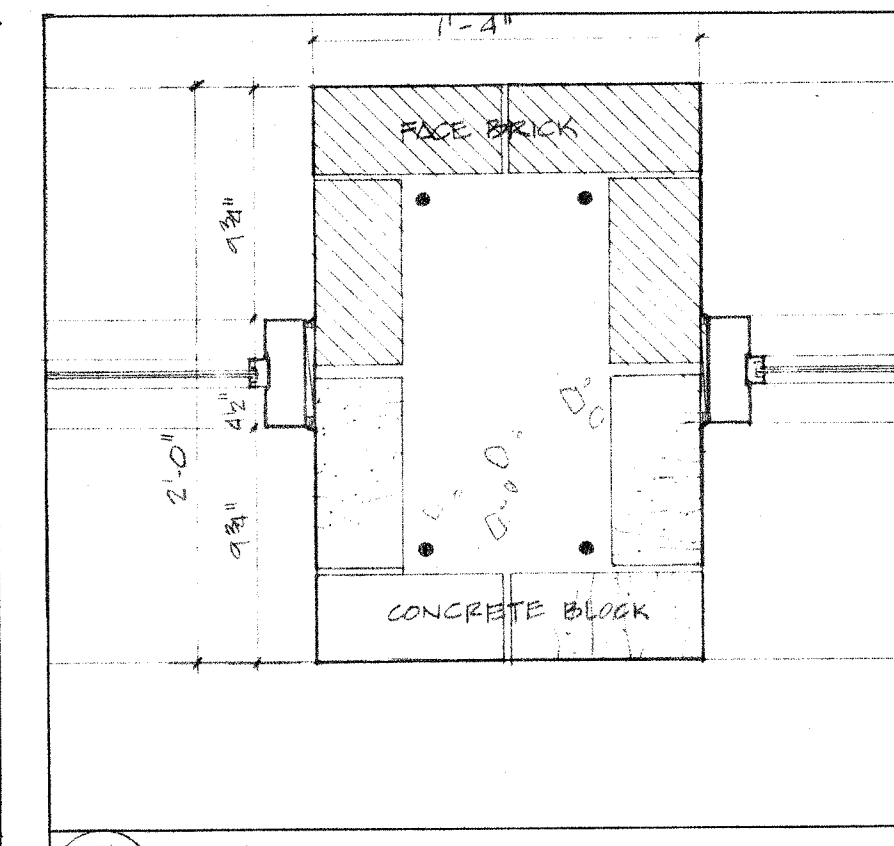


21 A10 PLAN OF MASONRY PIERS SCALE 1/2\"/>

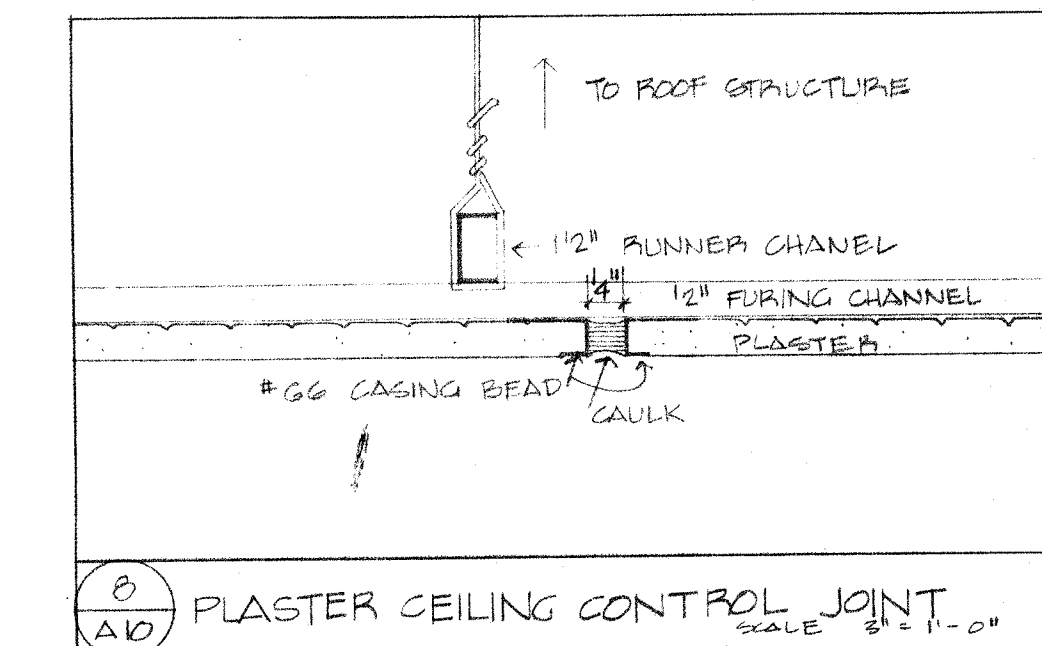


8 A10 PLASTER CEILING CONTROL JOINT SCALE 3/4\"/>

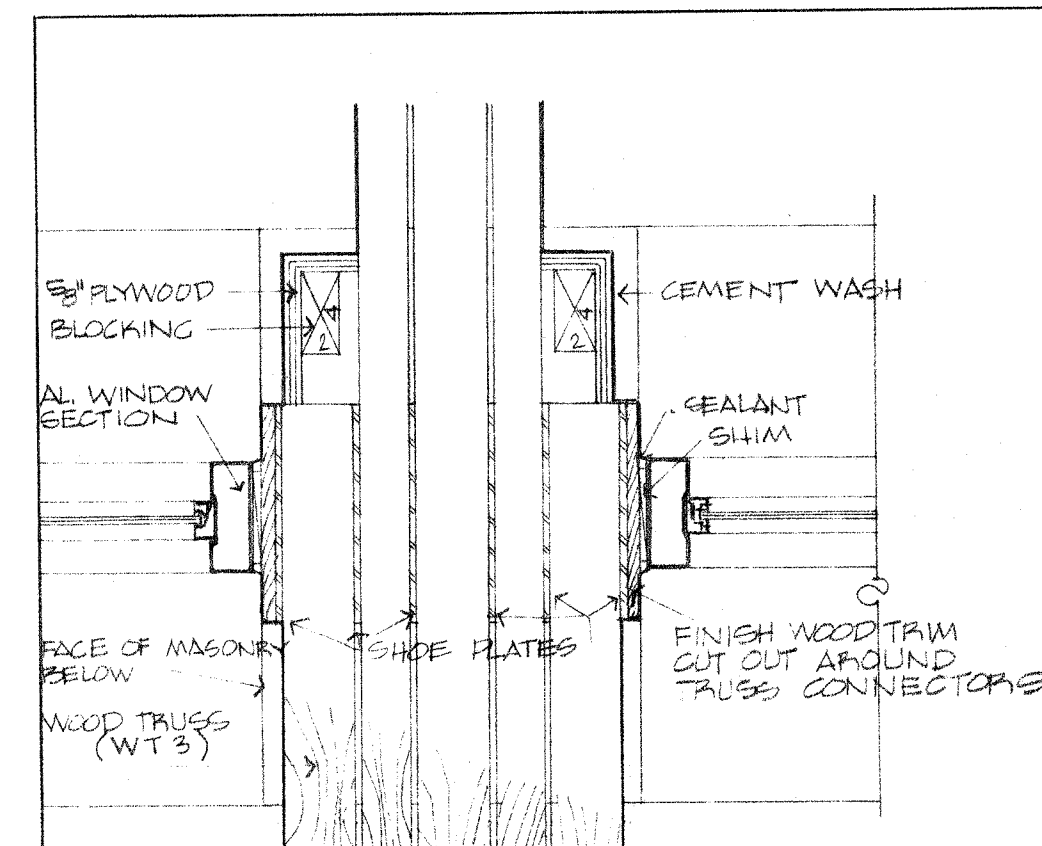


12 A10 PLAN OF TRUSS (WT 3) AT TOP OF MASONRY PIER SCALE 1/2\"/>

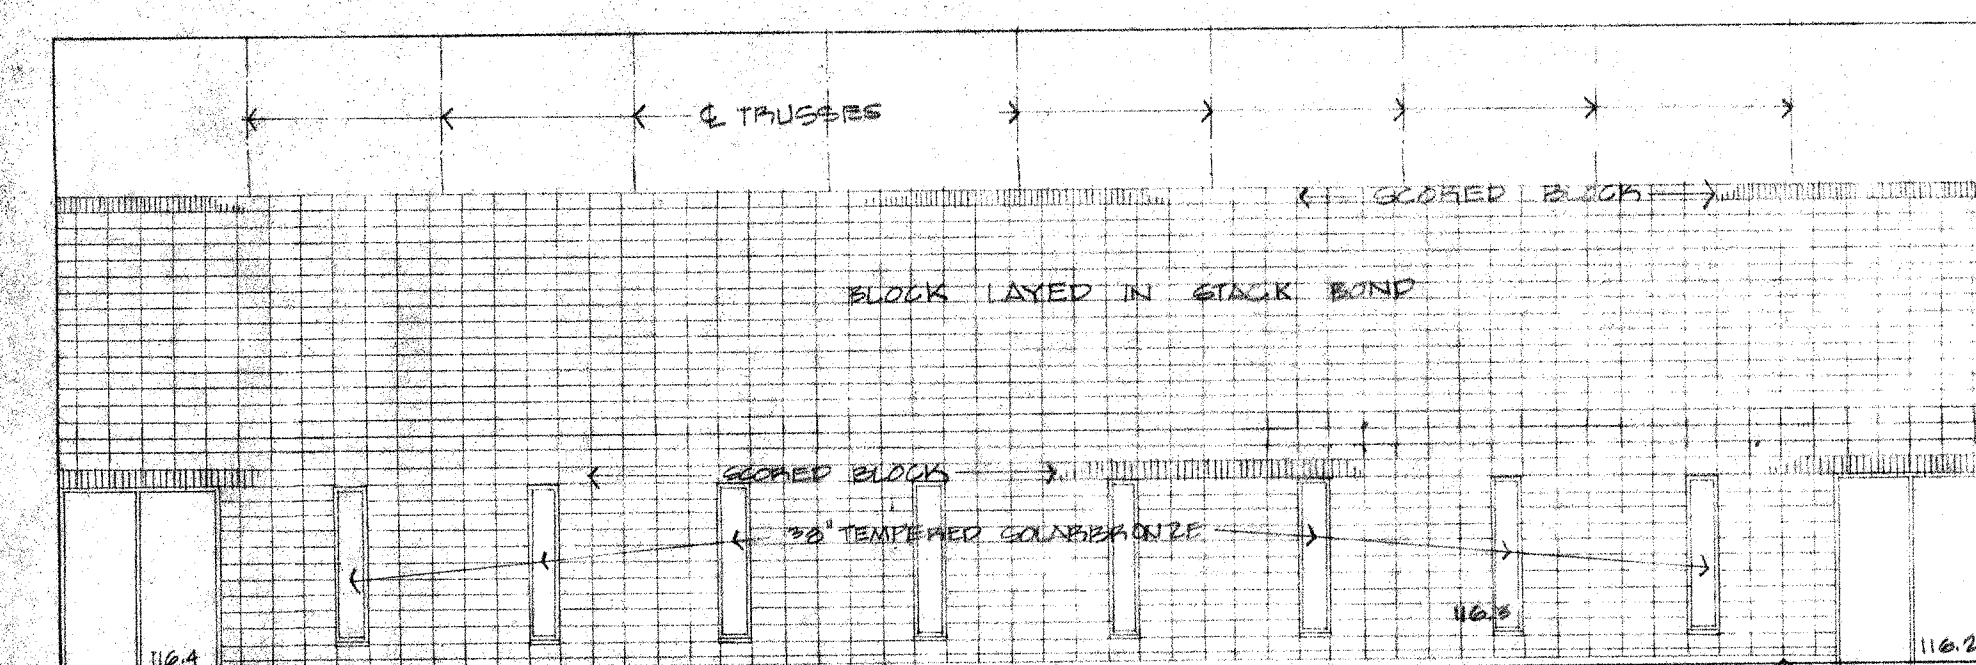


13 A10 MULTI-PURPOSE ROOM 116 NORTH WALL SCALE 1/2\"/>

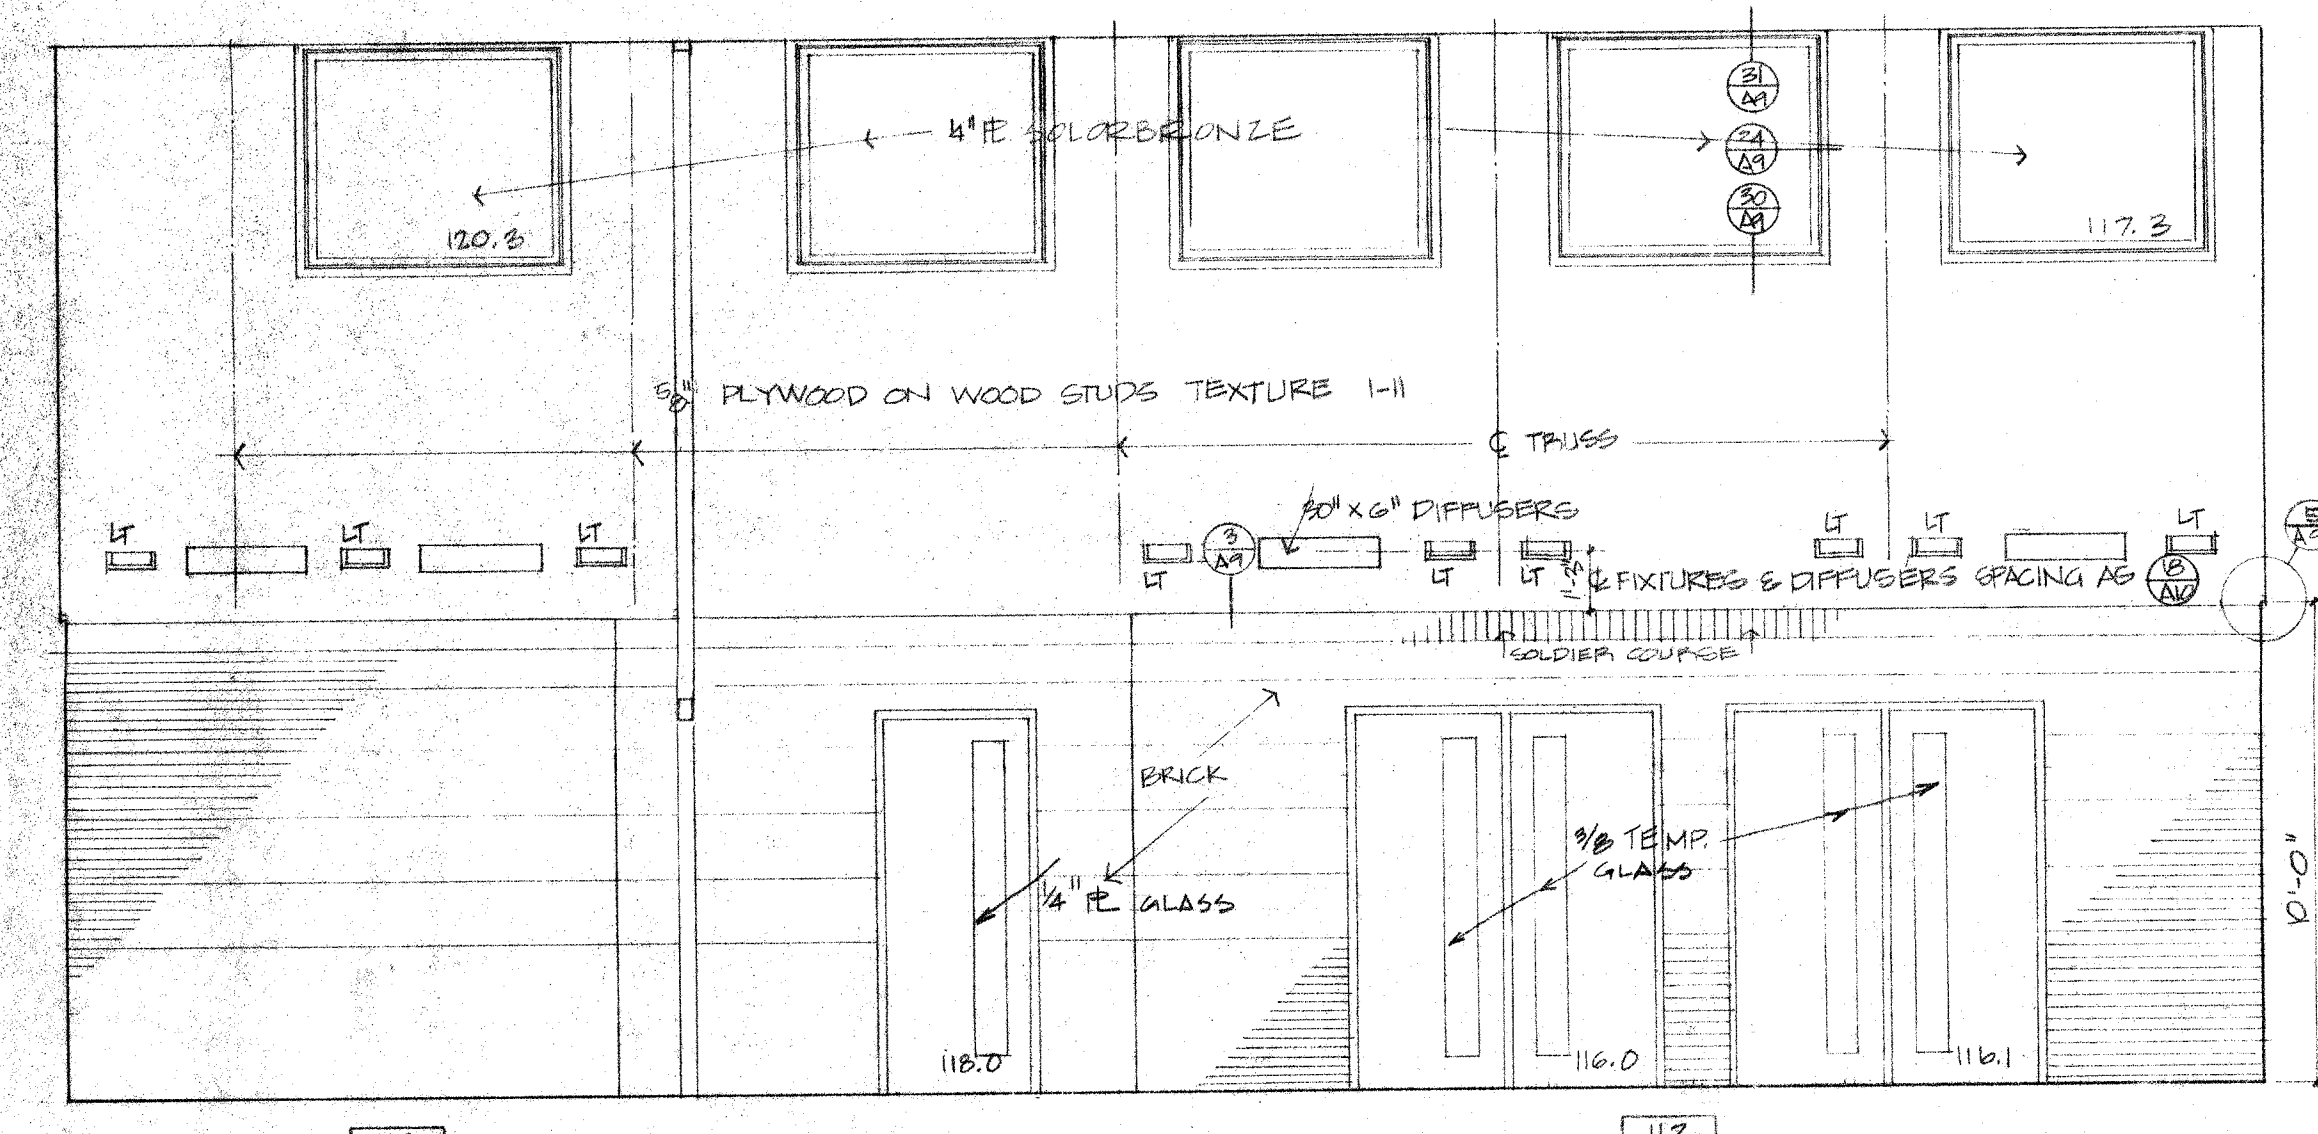


16 A10 TICKET LOBBY CONTROL OFFICE LOBBY ELEVATION 116 SCALE 1/4\"/>

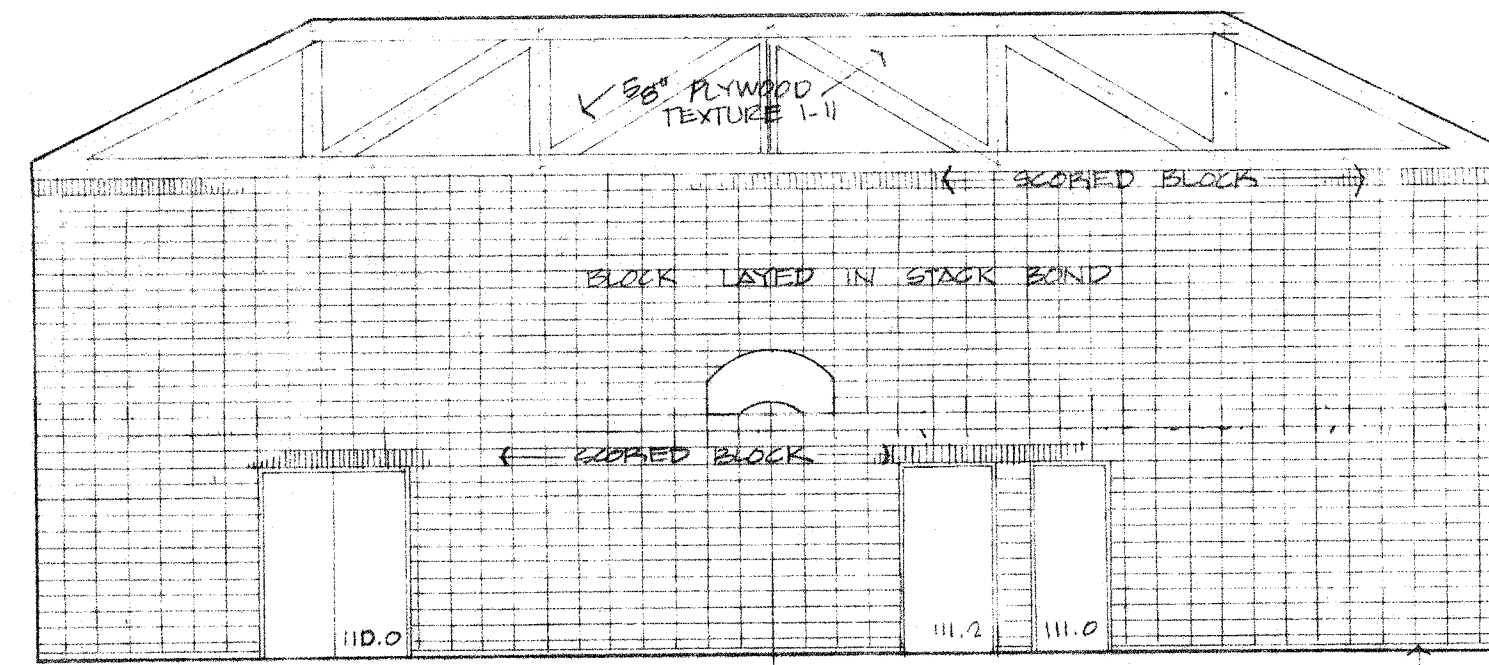


14 A10 MULTI-PURPOSE ROOM 116 EAST WALL SCALE 1/2\"/>

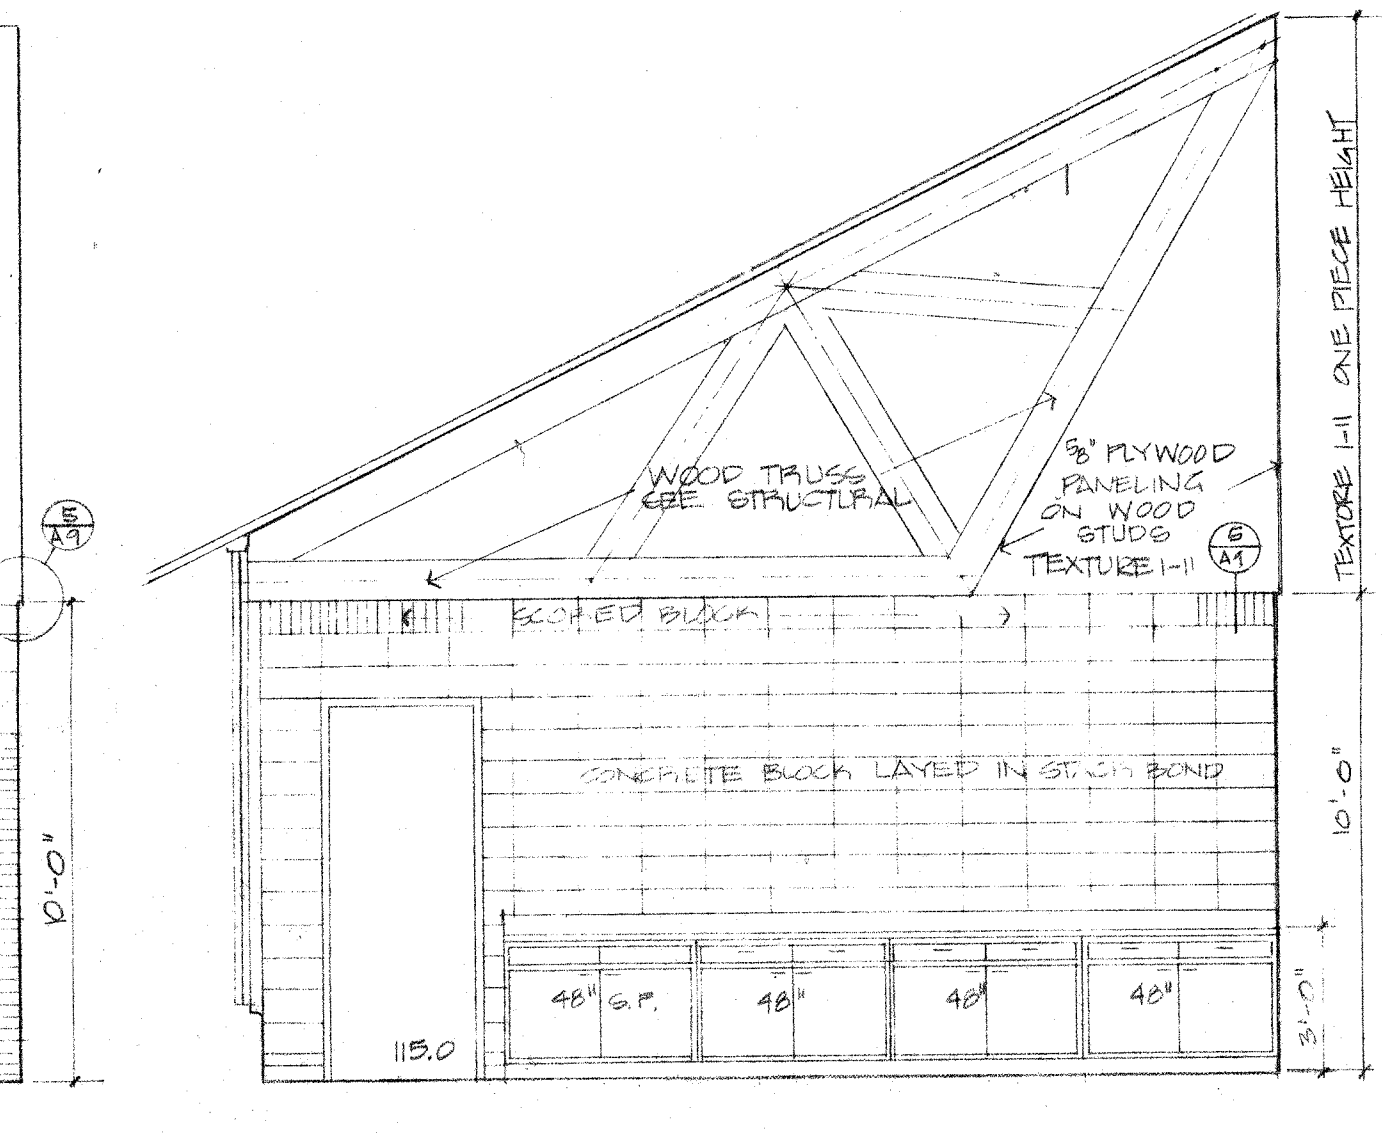


17 A10 MEETING & CRAFT 109 WEST WALL SCALE 1/4\"/>

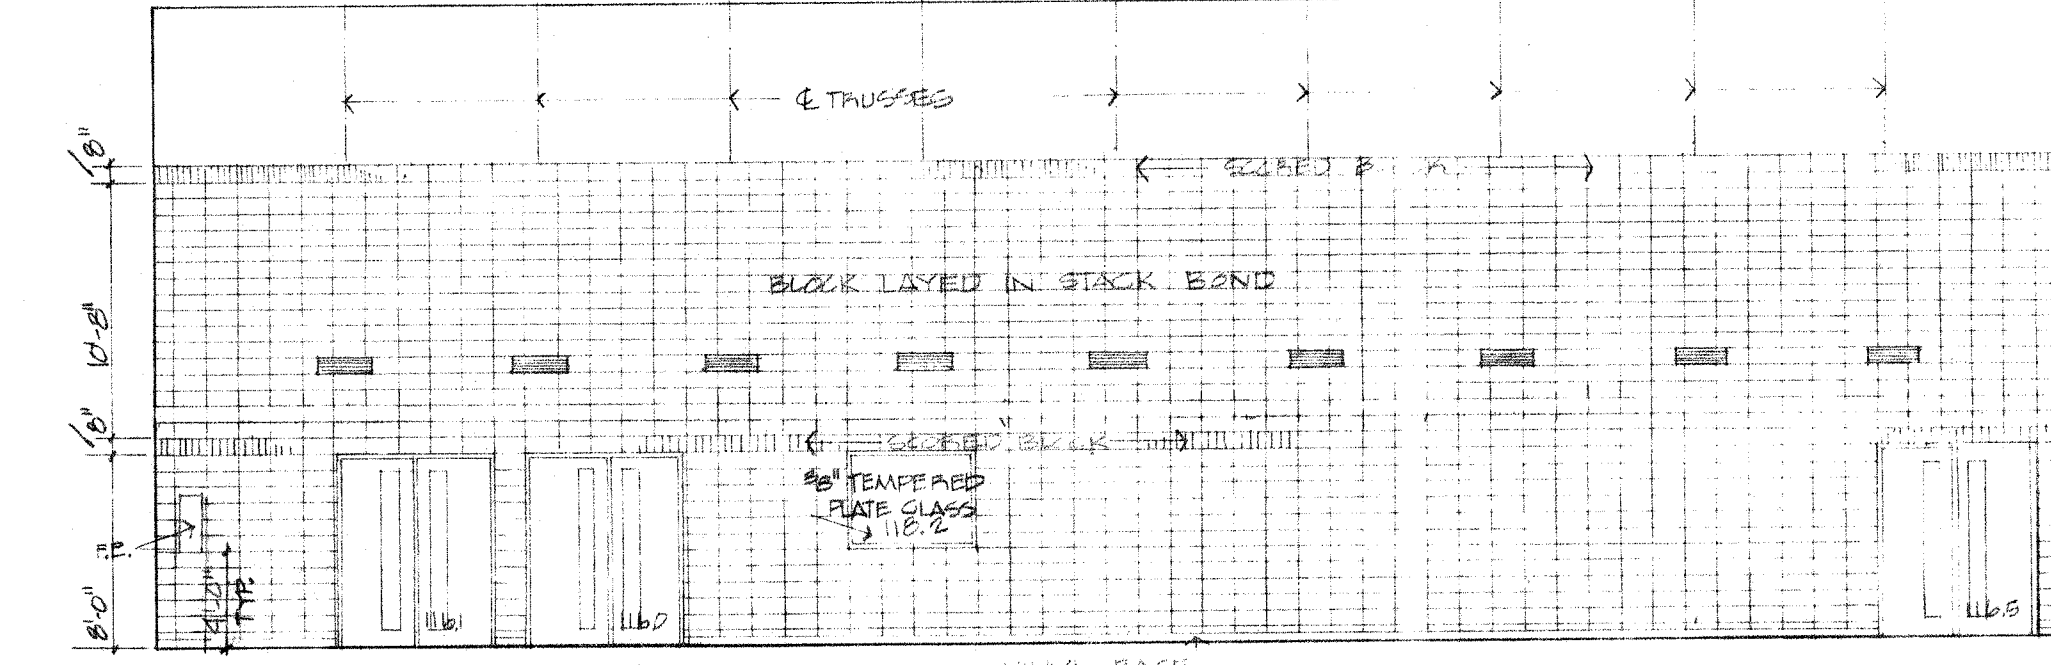


15 A10 MULTI-PURPOSE ROOM 116 SOUTH WALL SCALE 1/2\"/>

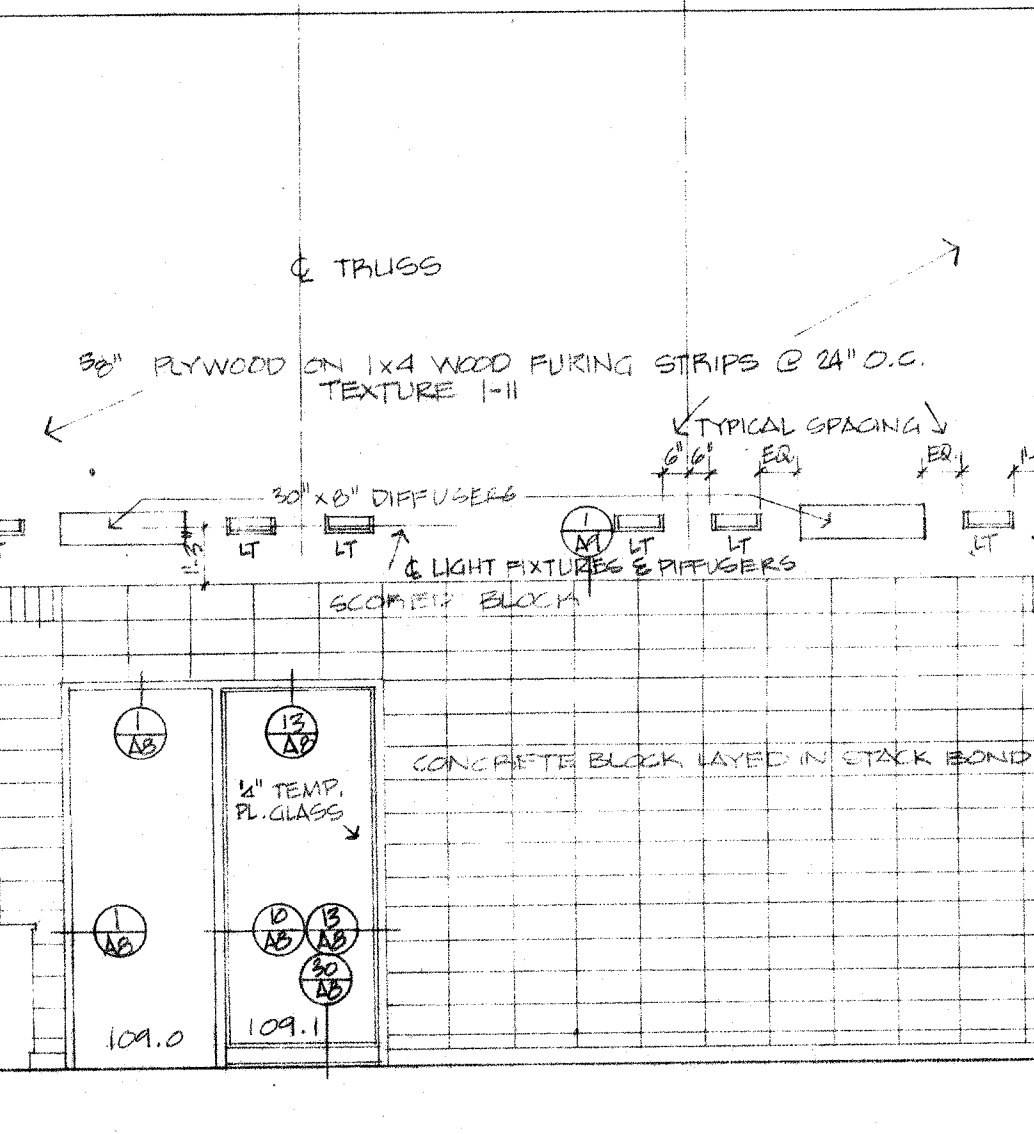


18 A10 MEETING & CRAFT 109 NORTH WALL SCALE 1/4\"/>

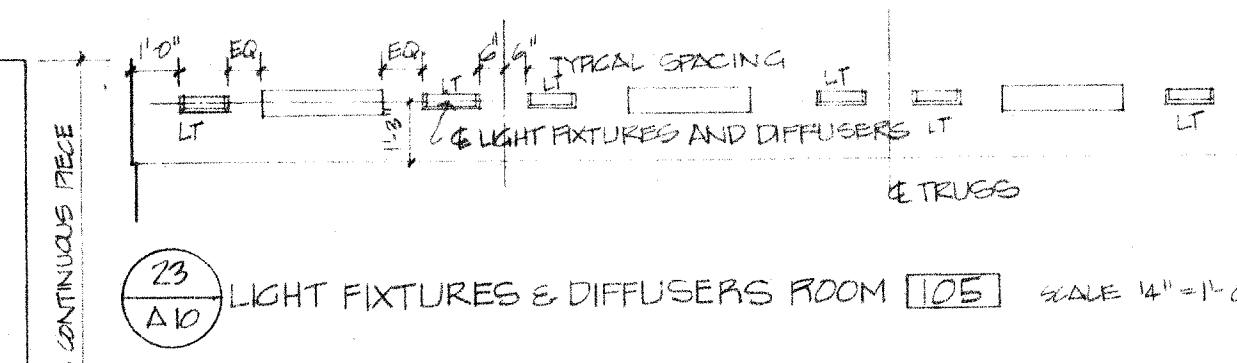


23 A10 LIGHT FIXTURES & DIFFUSERS ROOM 105 SCALE 1/4\"/>

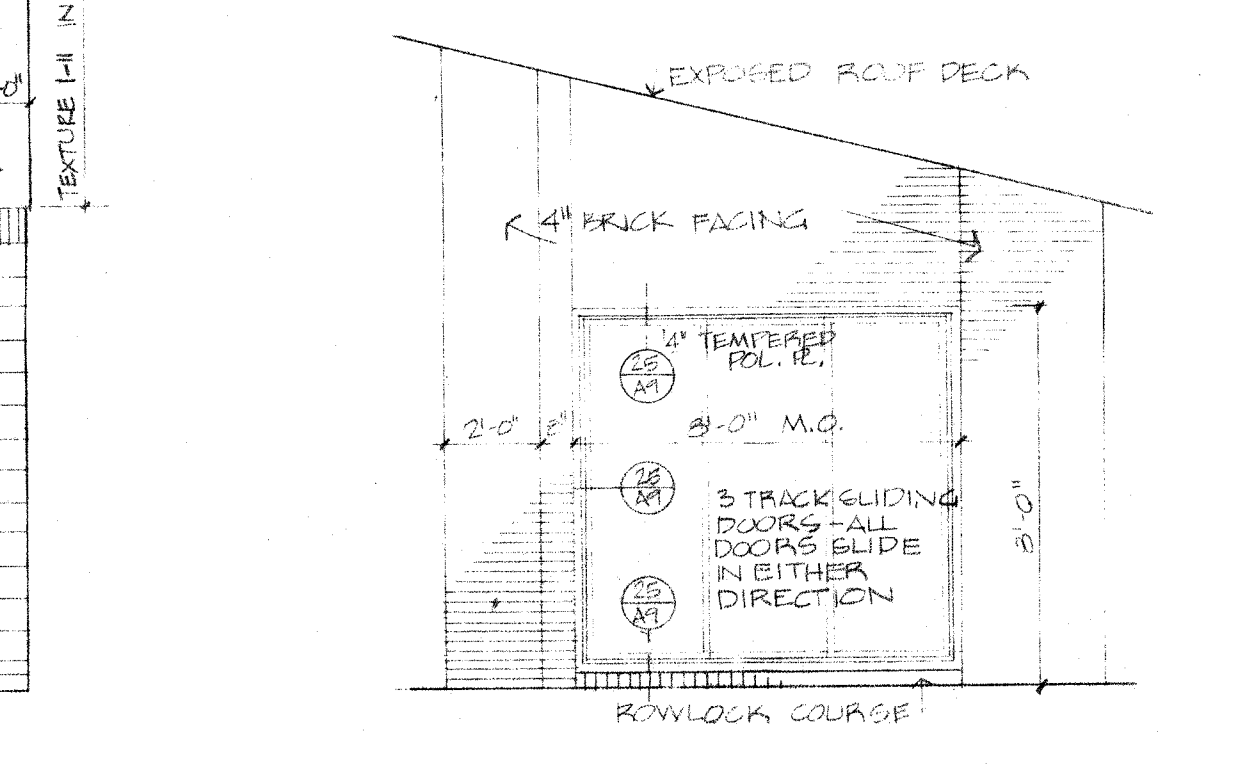

19 A10 TROPHY CASE SCALE 1/4\"/>

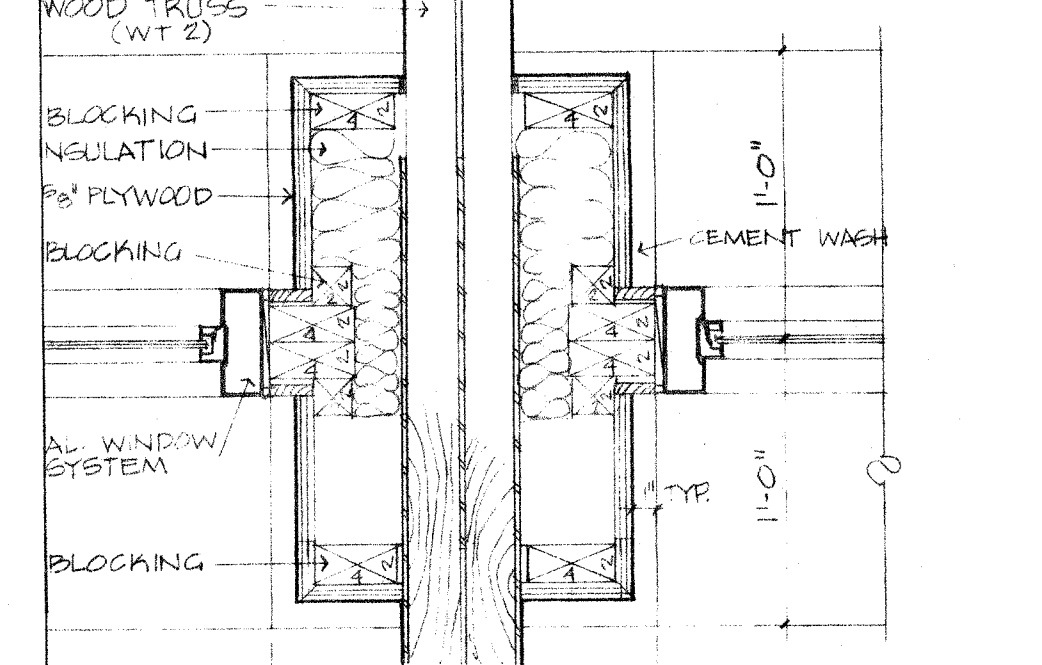

16 A10 PLAN OF TRUSS (WT 2) AT TOP OF MASONRY PIER SCALE 1/2\"/>

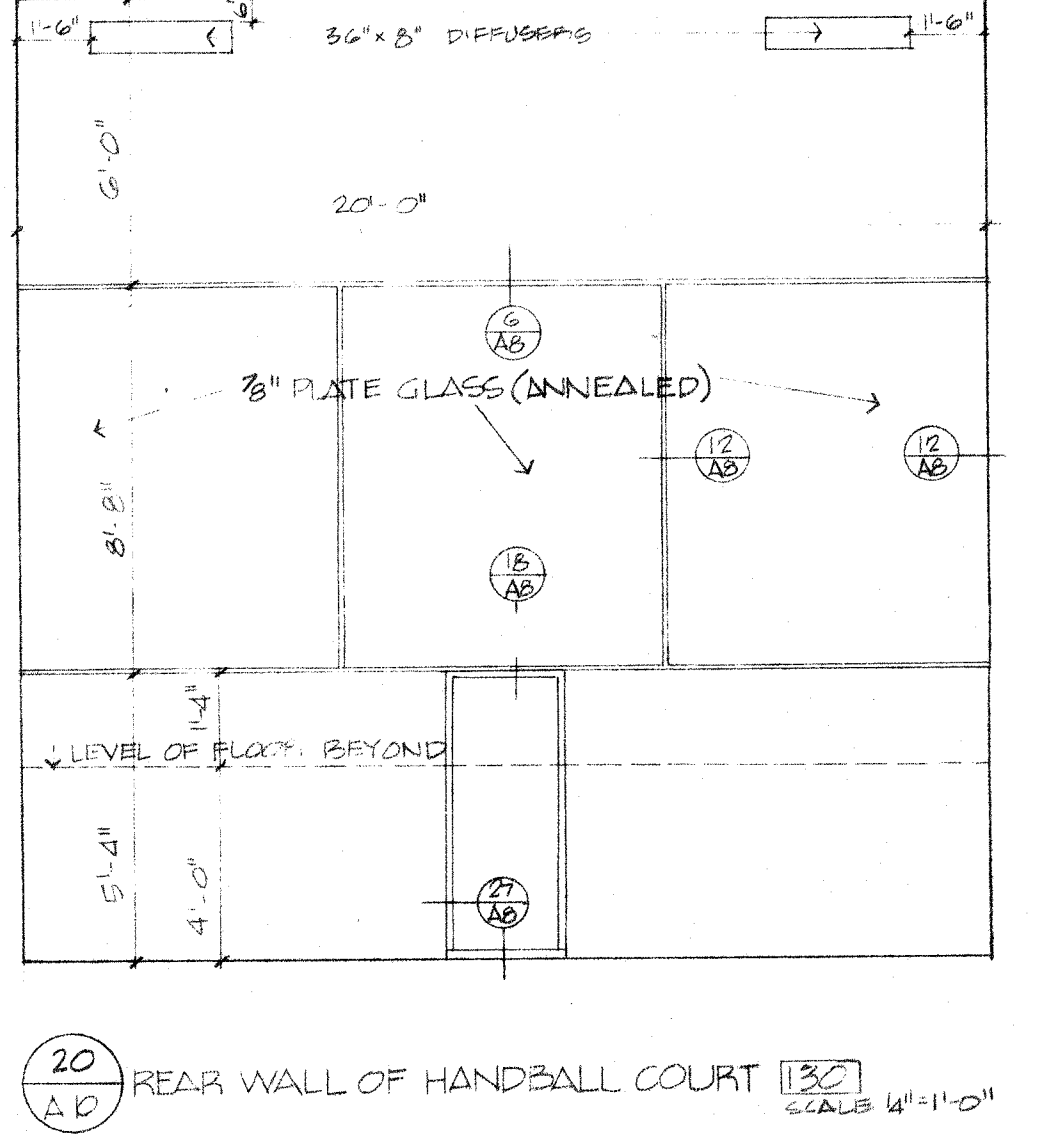

20 A10 REAR WALL OF HANDBALL COURT 130 SCALE 1/2\"/>

INTERIOR DETAILS & ELEVATIONS



Hastings & Chivetta Architects

7733 Forsyth Boulevard, Clayton, Missouri 63105 314-863-5717

Frank A. Romano & Associates



Hansen Engineering Henicke & Theiss

Bellefontaine Neighbors Community Center

MAYOR RAYMOND ZIELINSKI

Job No. 1100 Date: AUG 5, 1974 Revisions:

A10

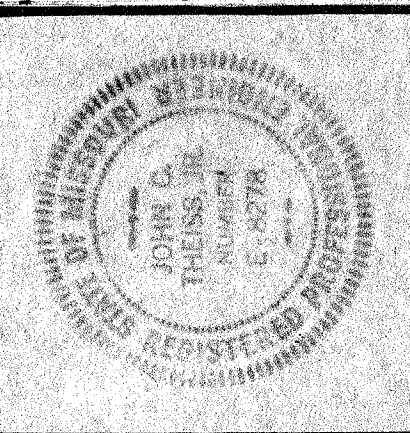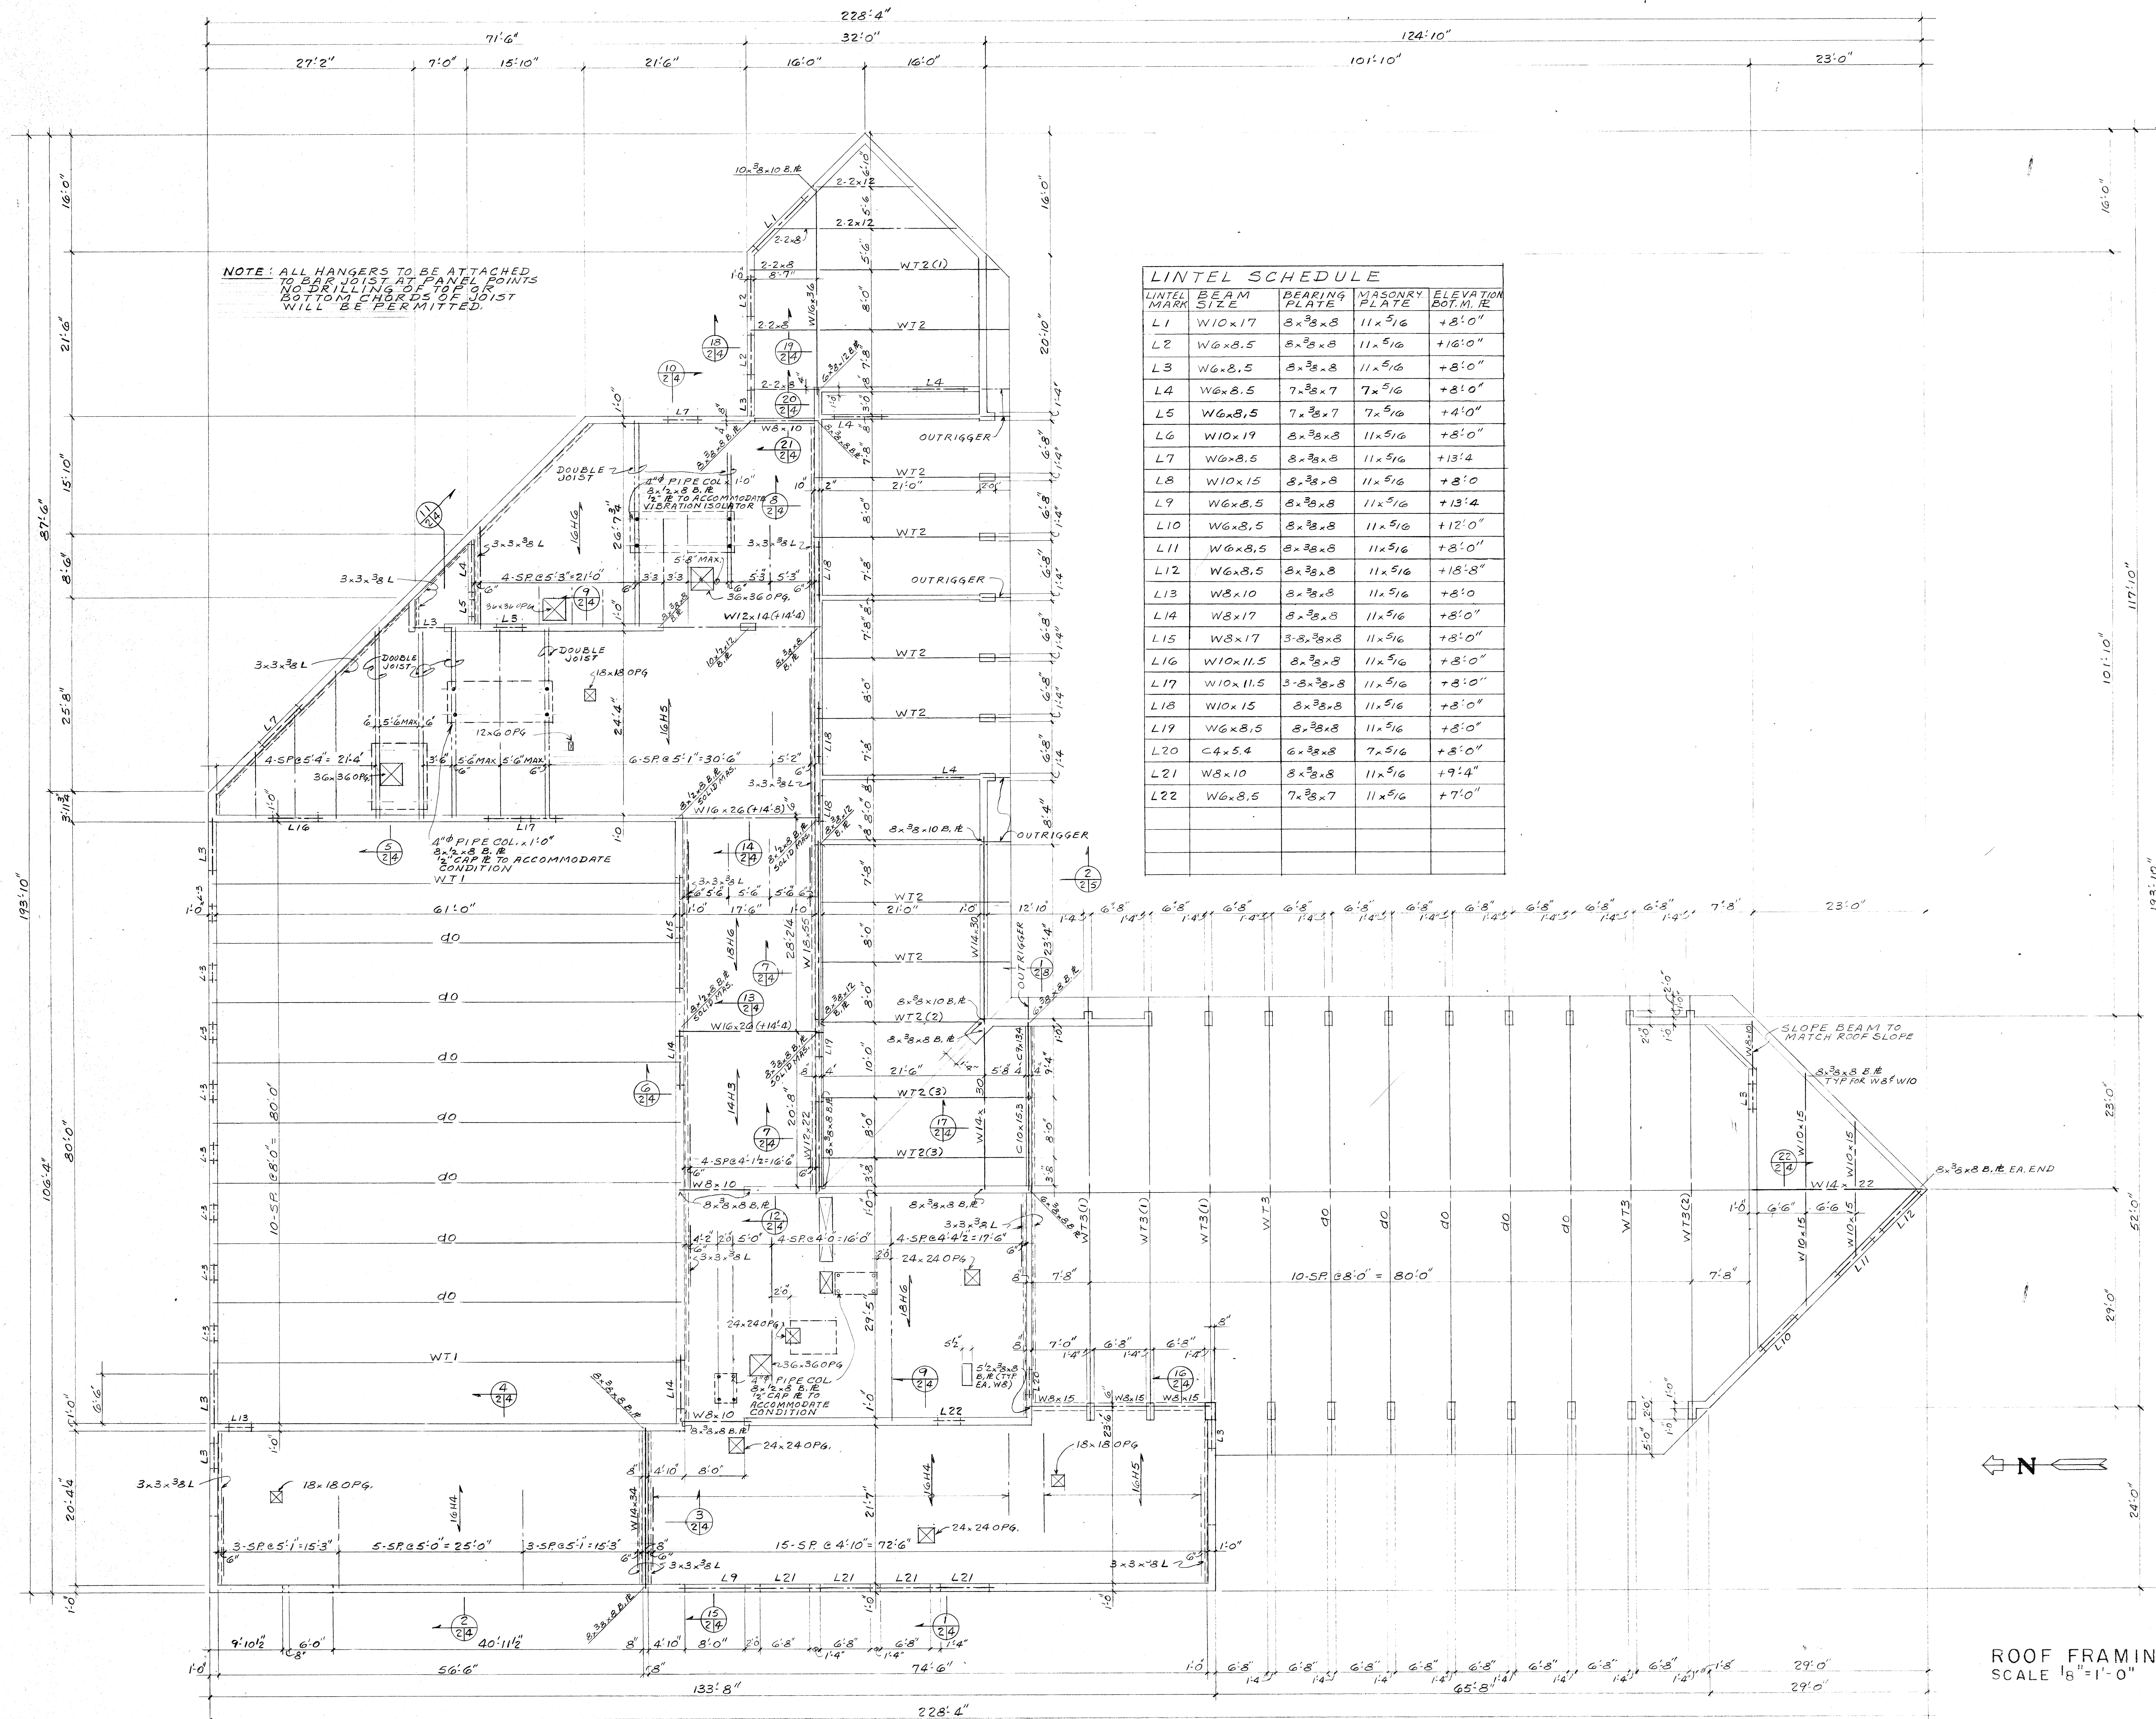

Hastings & Chivetta Architects


7733 Forsyth Boulevard, Clayton, Missouri 63105 314-863-5717
 Mechanical Engineers
 Electrical Engineers
 Structural Engineers

**Bellefontaine Neighbors
Community Center**

MAYOR RAYMOND ZIELINSKI


Job No.	
Date:	
Revisions:	

S2

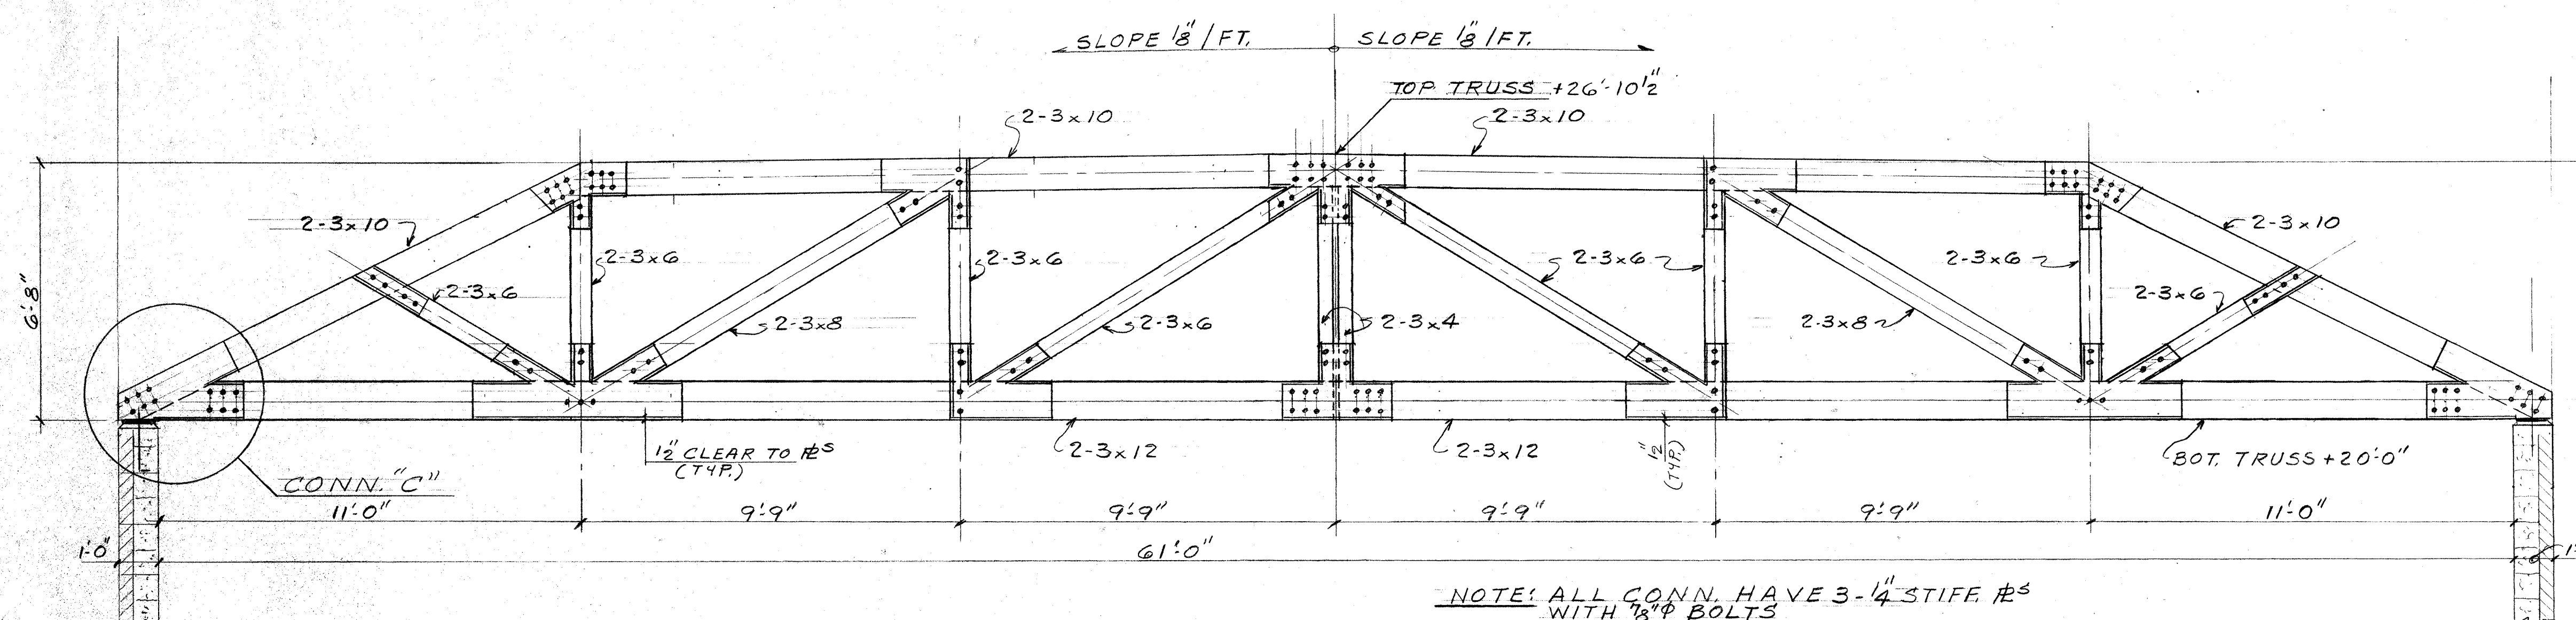

WOOD TRUSS (WT1)
SCALE: 3/8"=1'-0"


NOTE: ALL CONN. HAVE 3-1/4" STIFF. #5 WITH 1/8" BOLTS

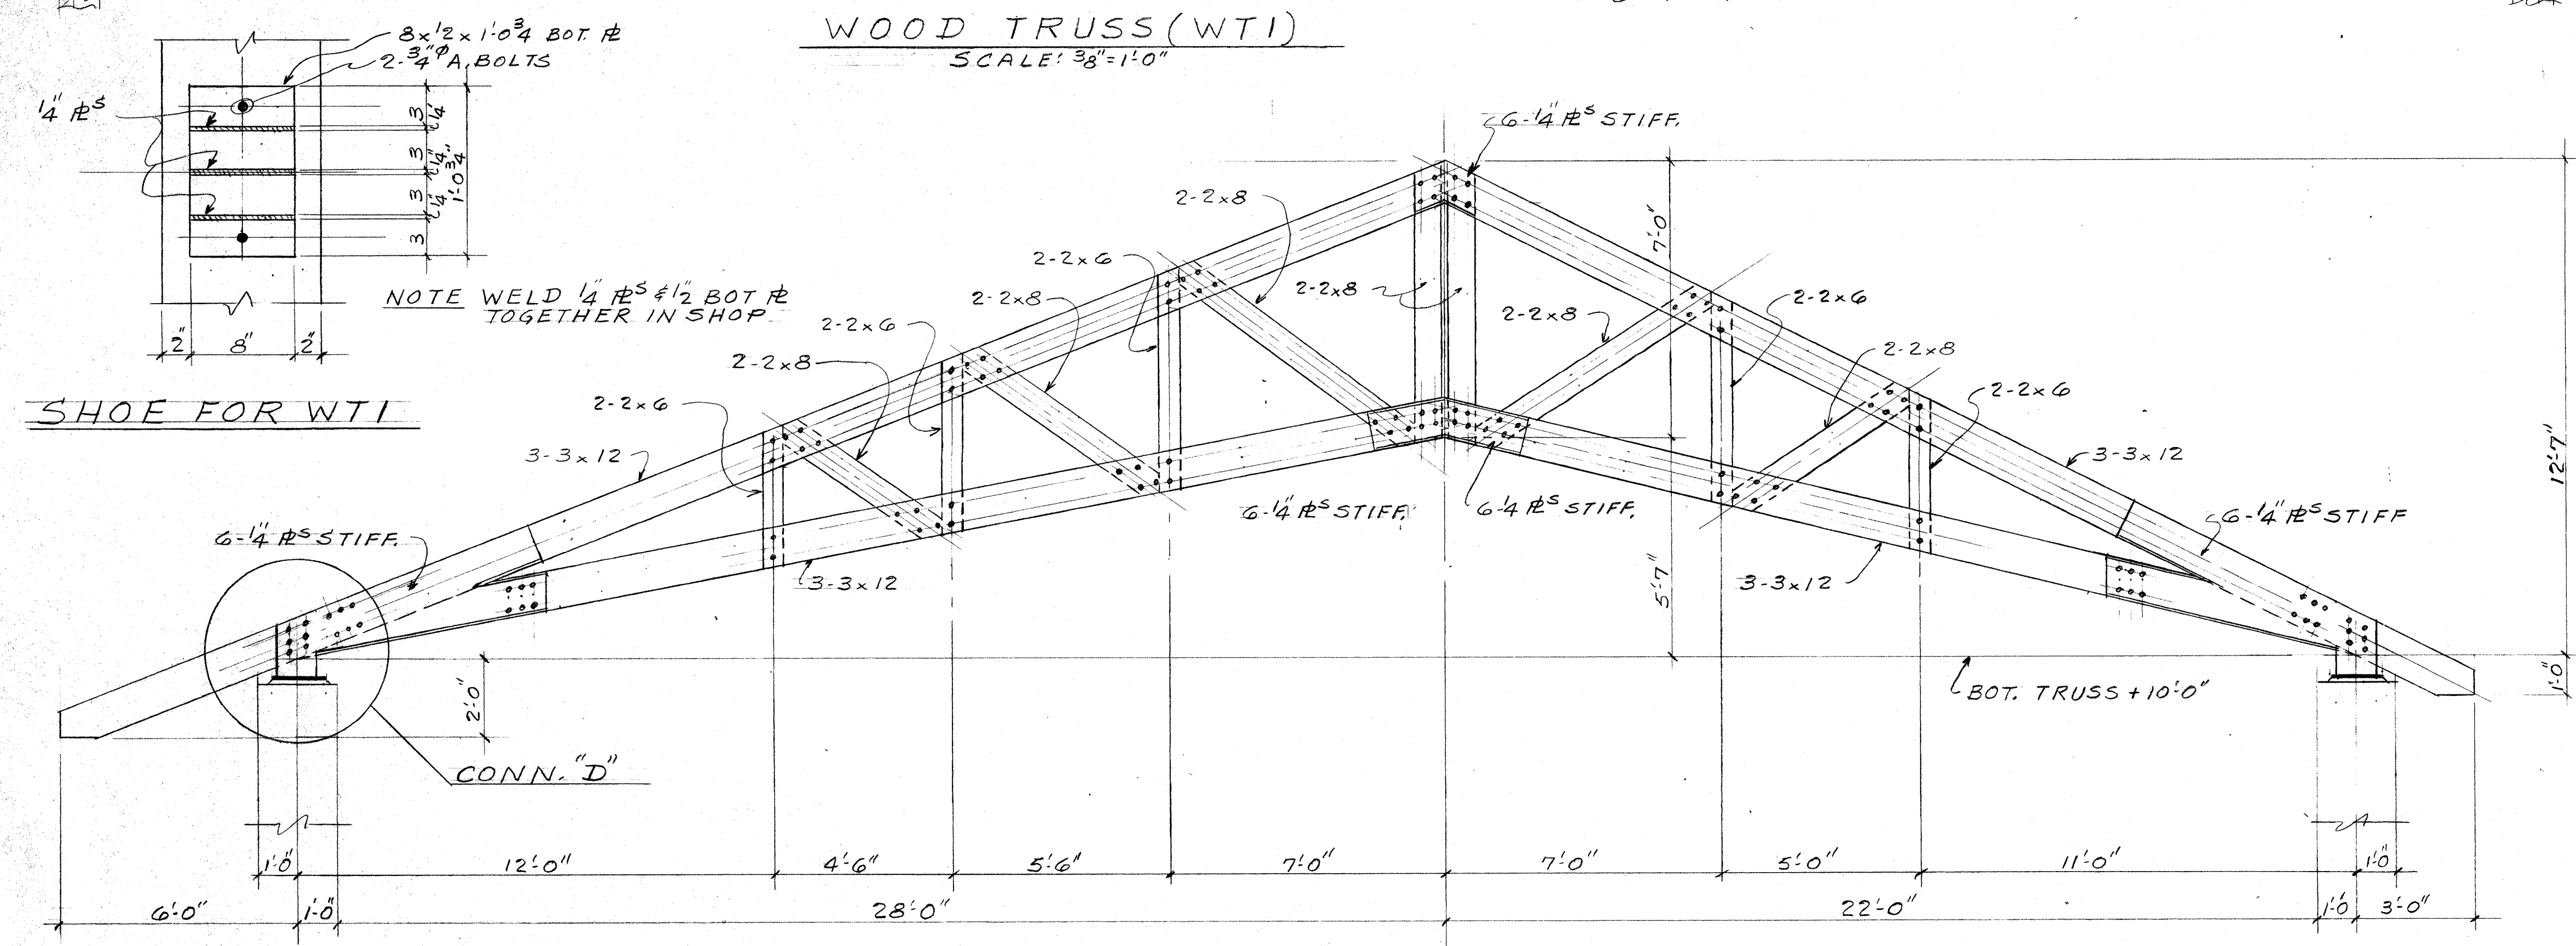

SHOE FOR WT1

WOOD TRUSS (WT3)
SCALE: 3/8"=1'-0"

NOTE: ALL CONN. HAVE 4-1/4" FILLER #5 UNLESS NOTED WITH 1/8" BOLTS

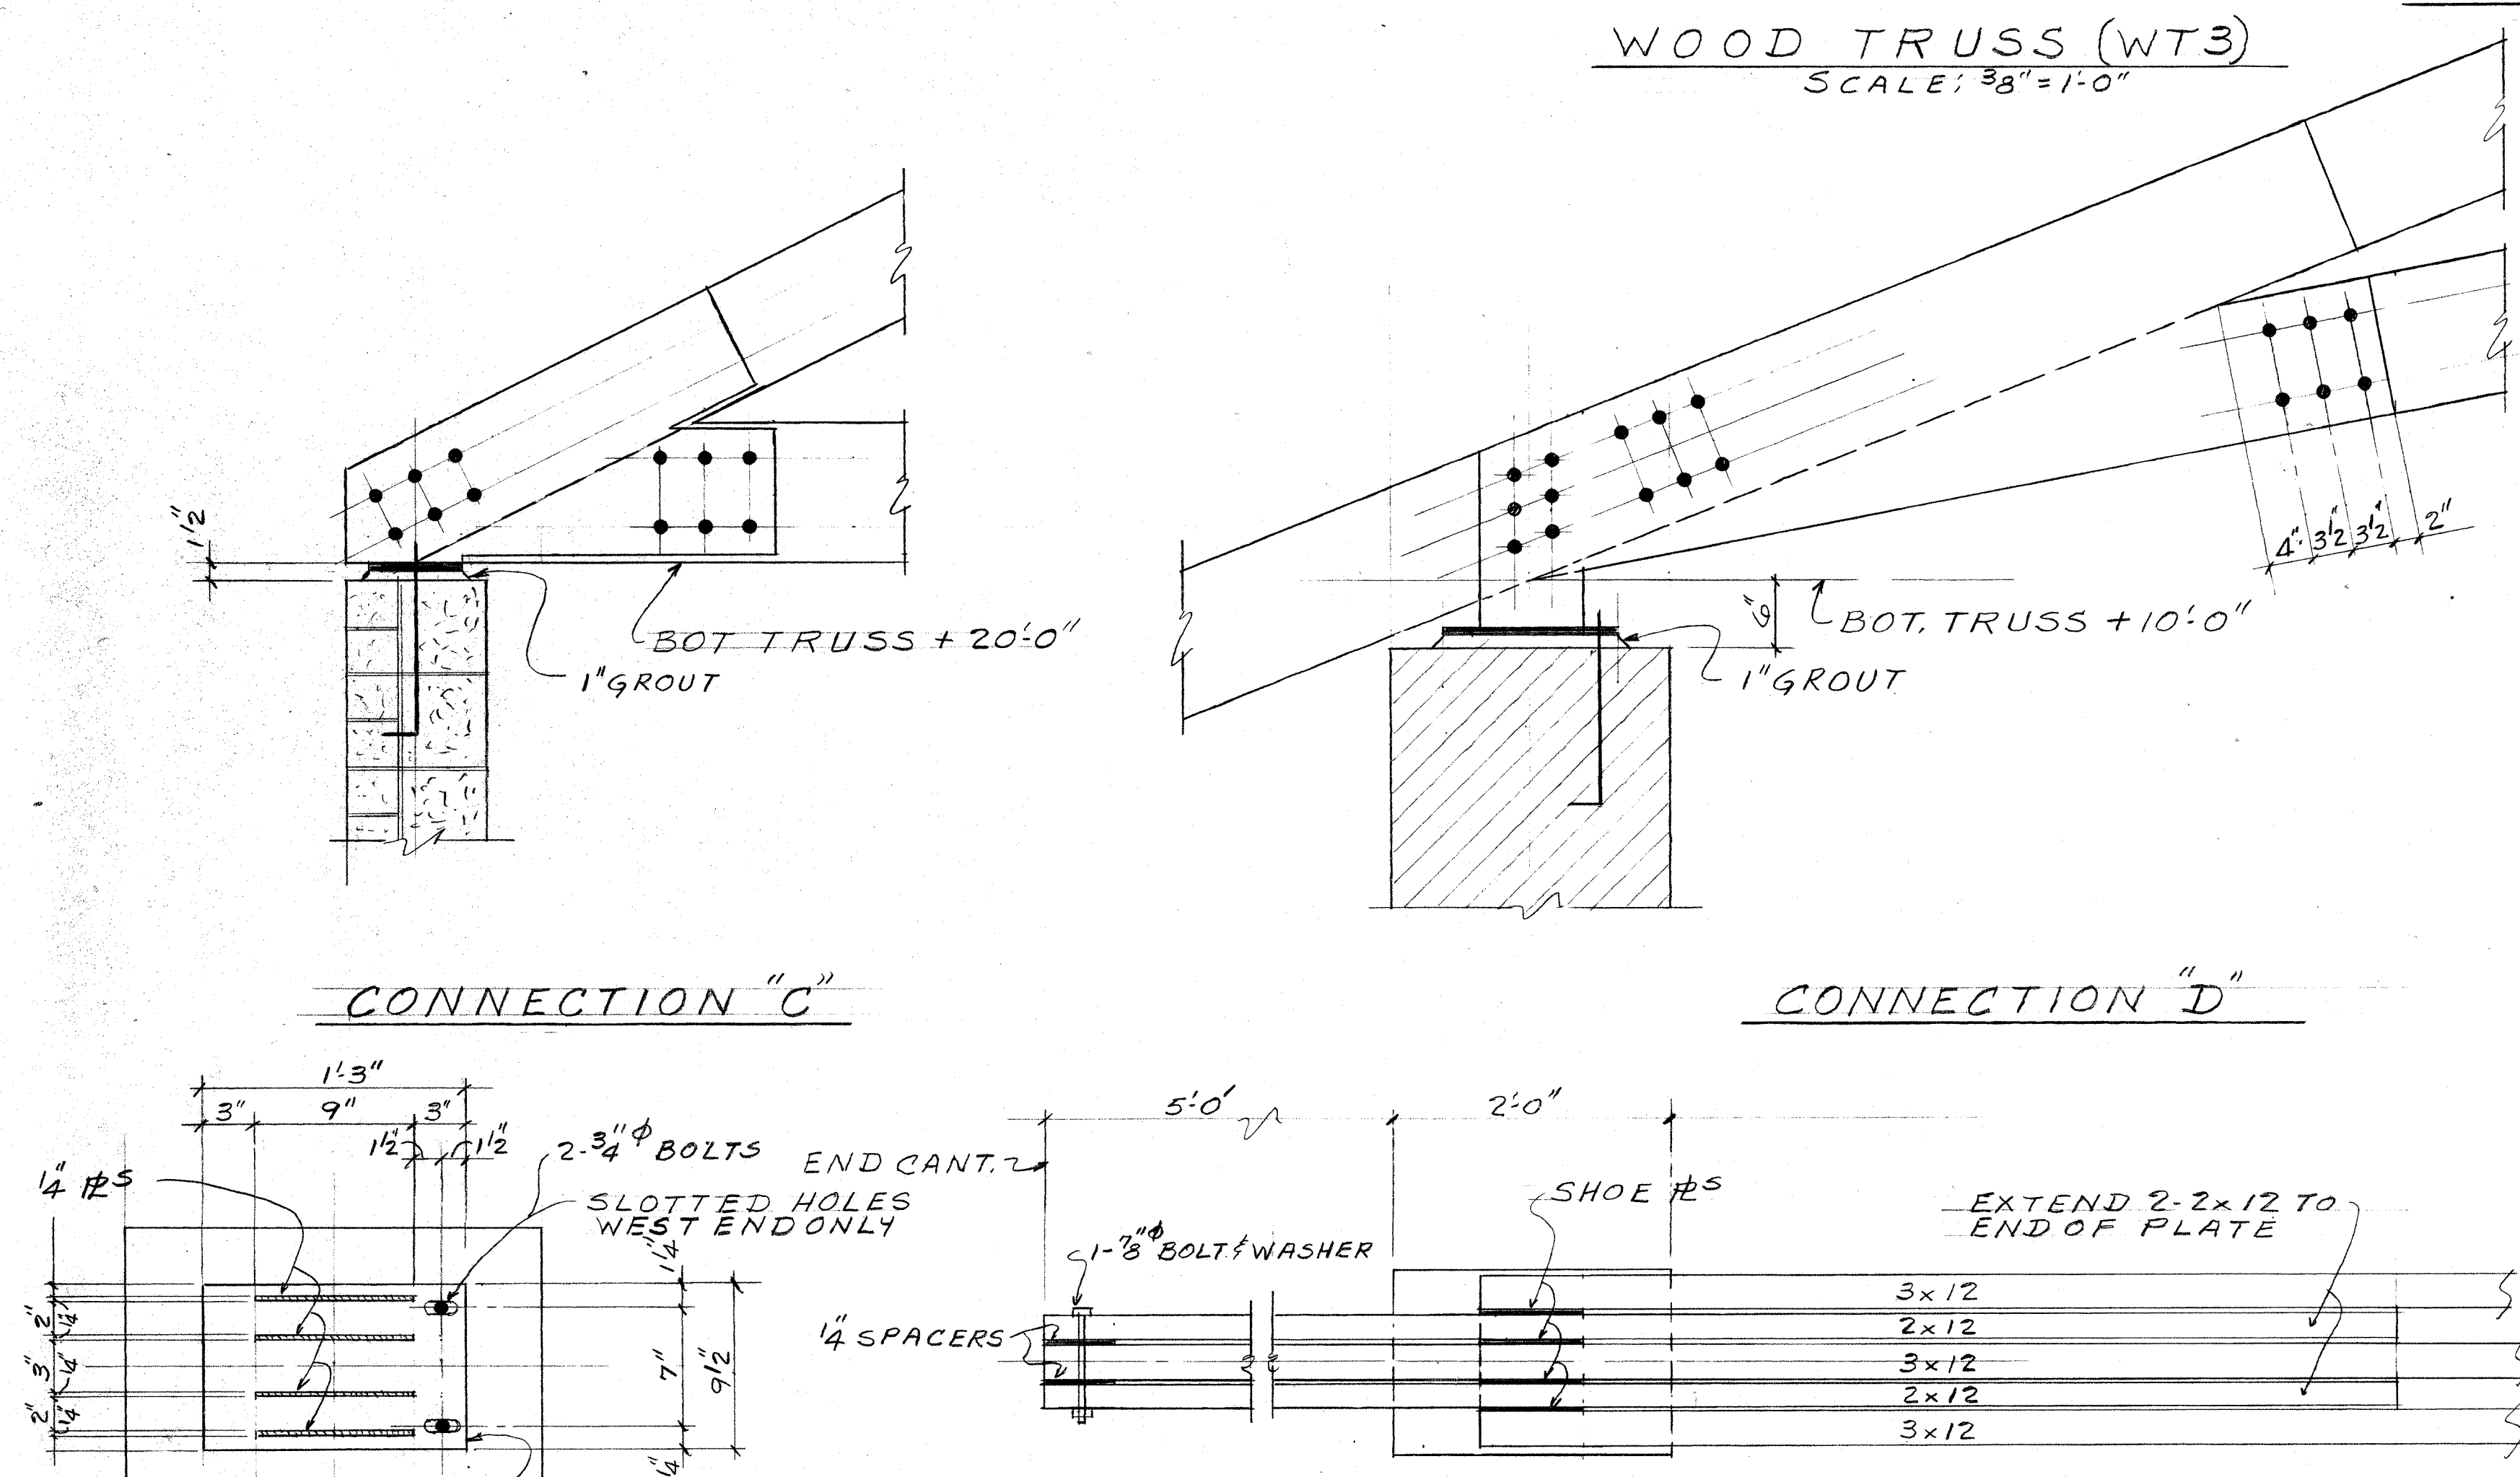


CONNECTION "C"

CONNECTION "D"


END PLAN OF TRUSS WT3

SHOE FOR WT3

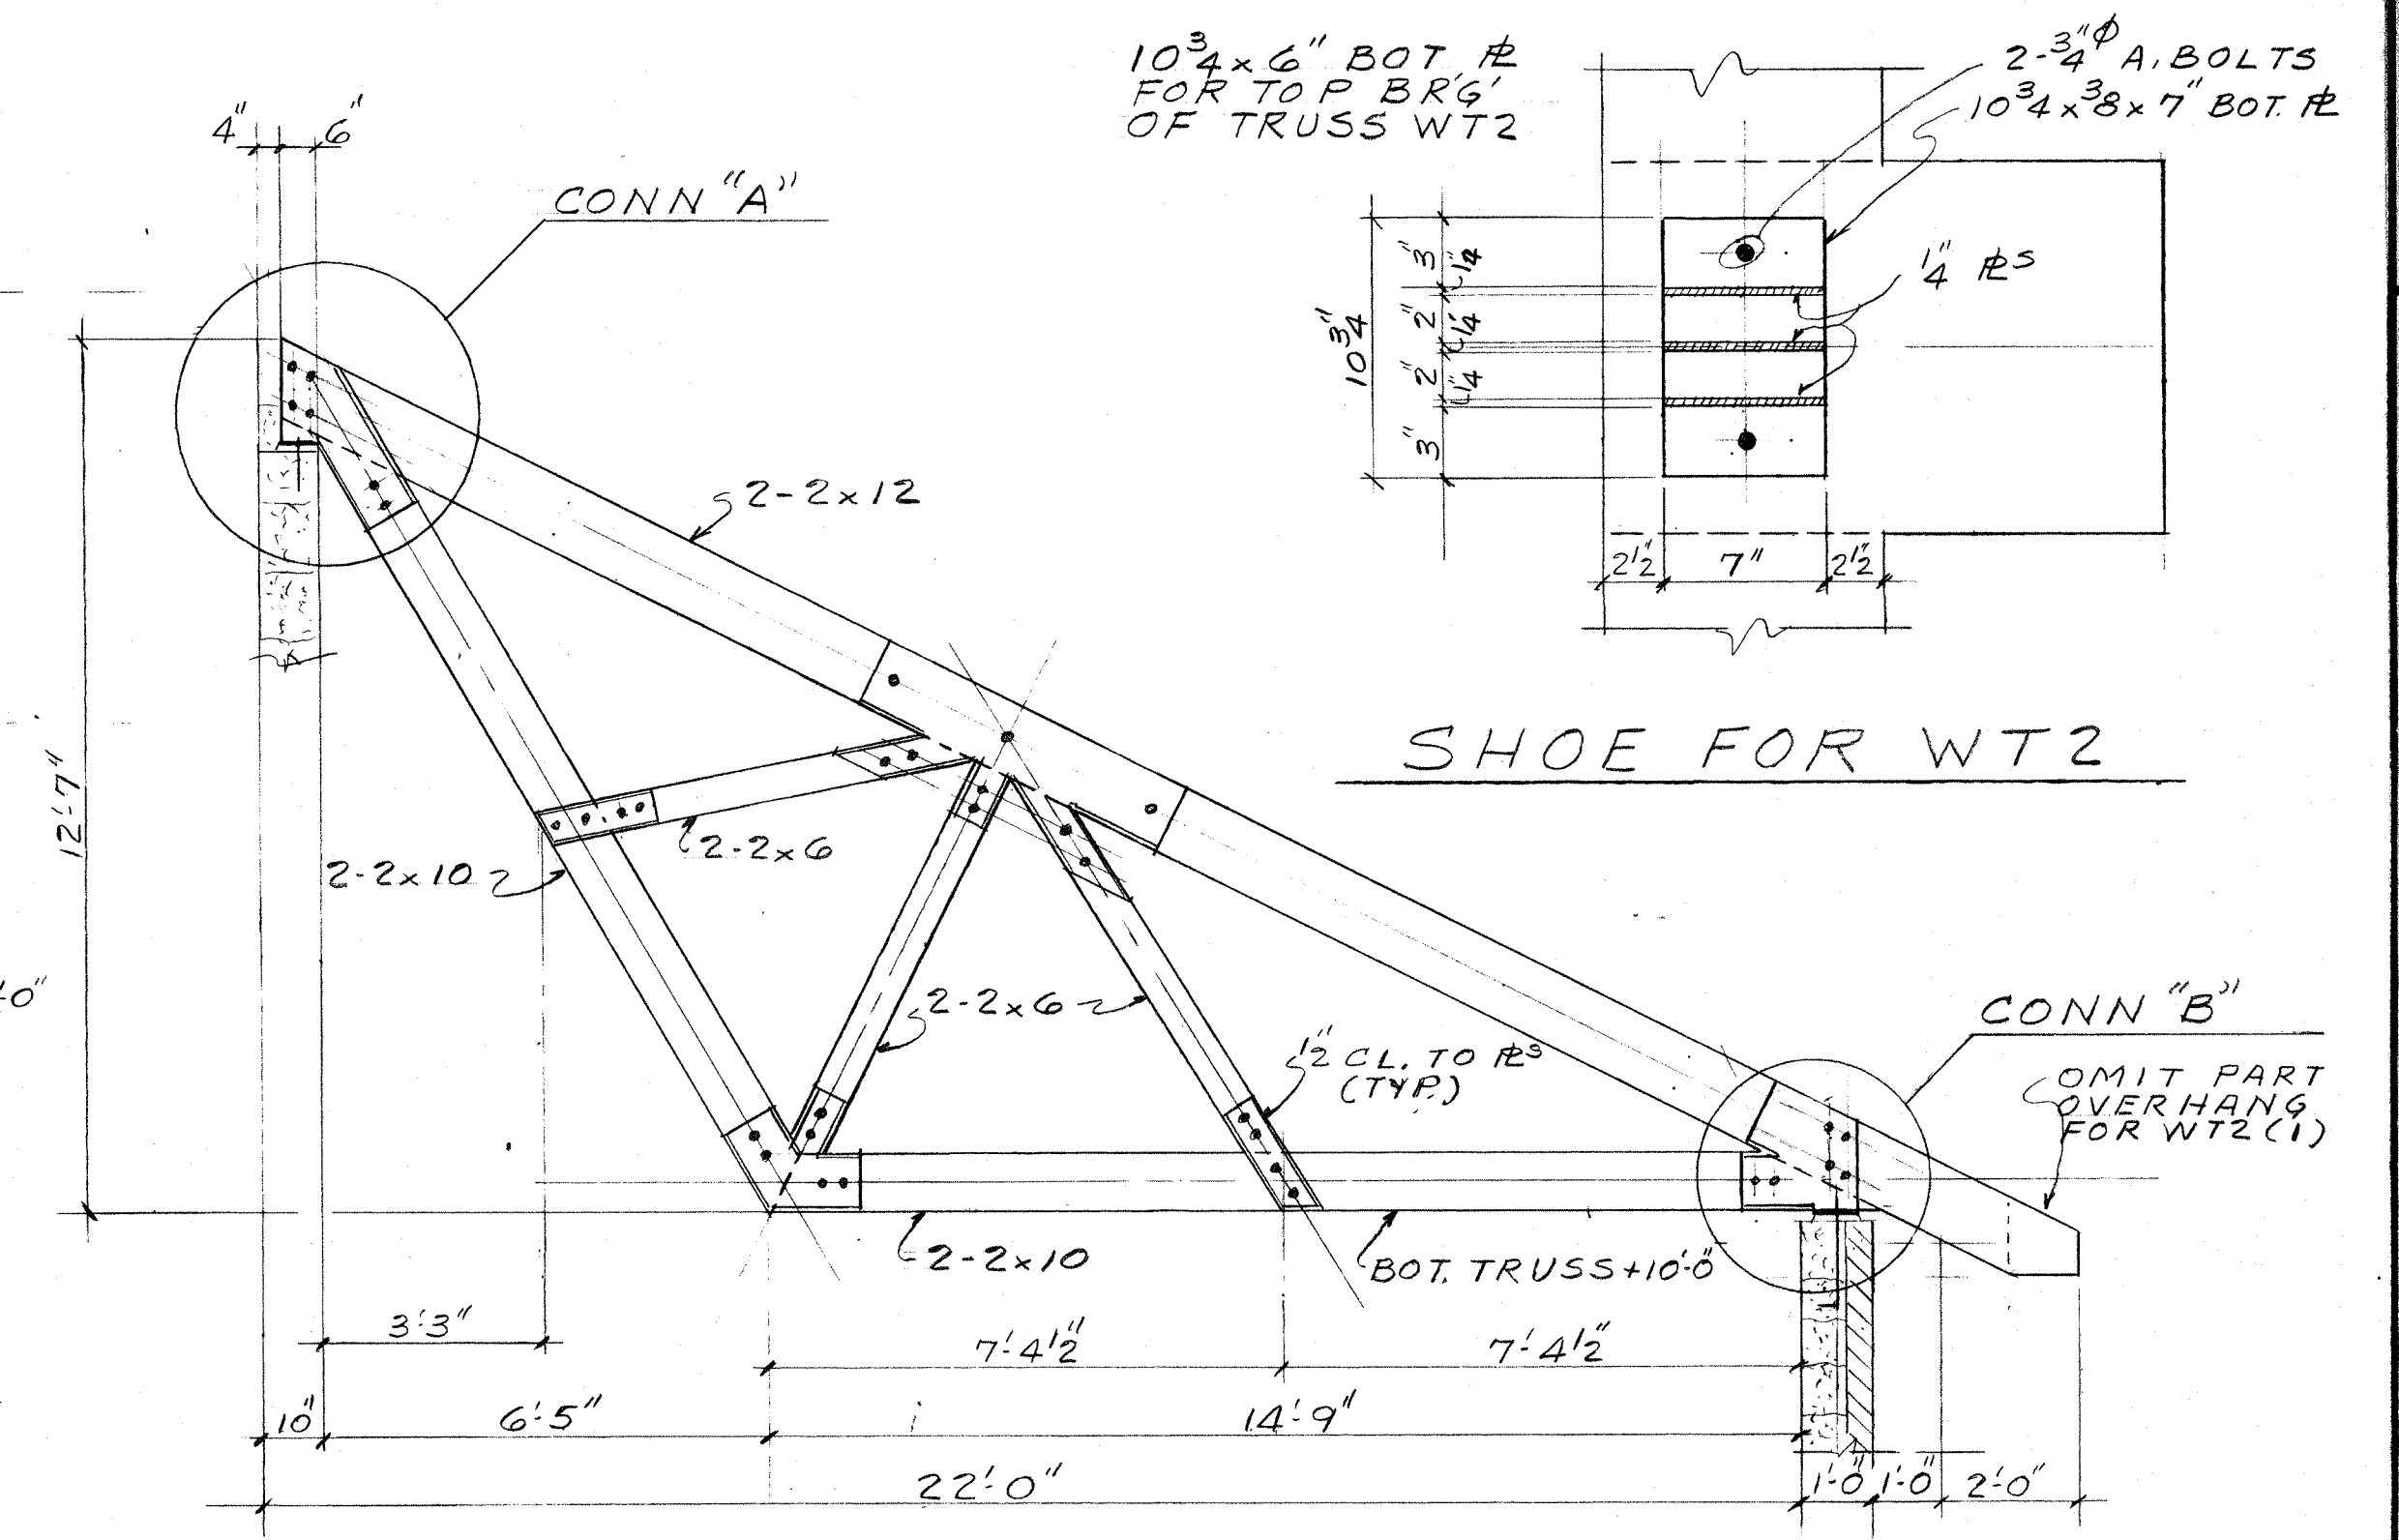


WOOD TRUSS (WT2)
SCALE: 3/8"=1'-0"

NOTE: ALL CONN. HAVE 3-1/4" STIFF. #5 WITH 1/8" BOLTS

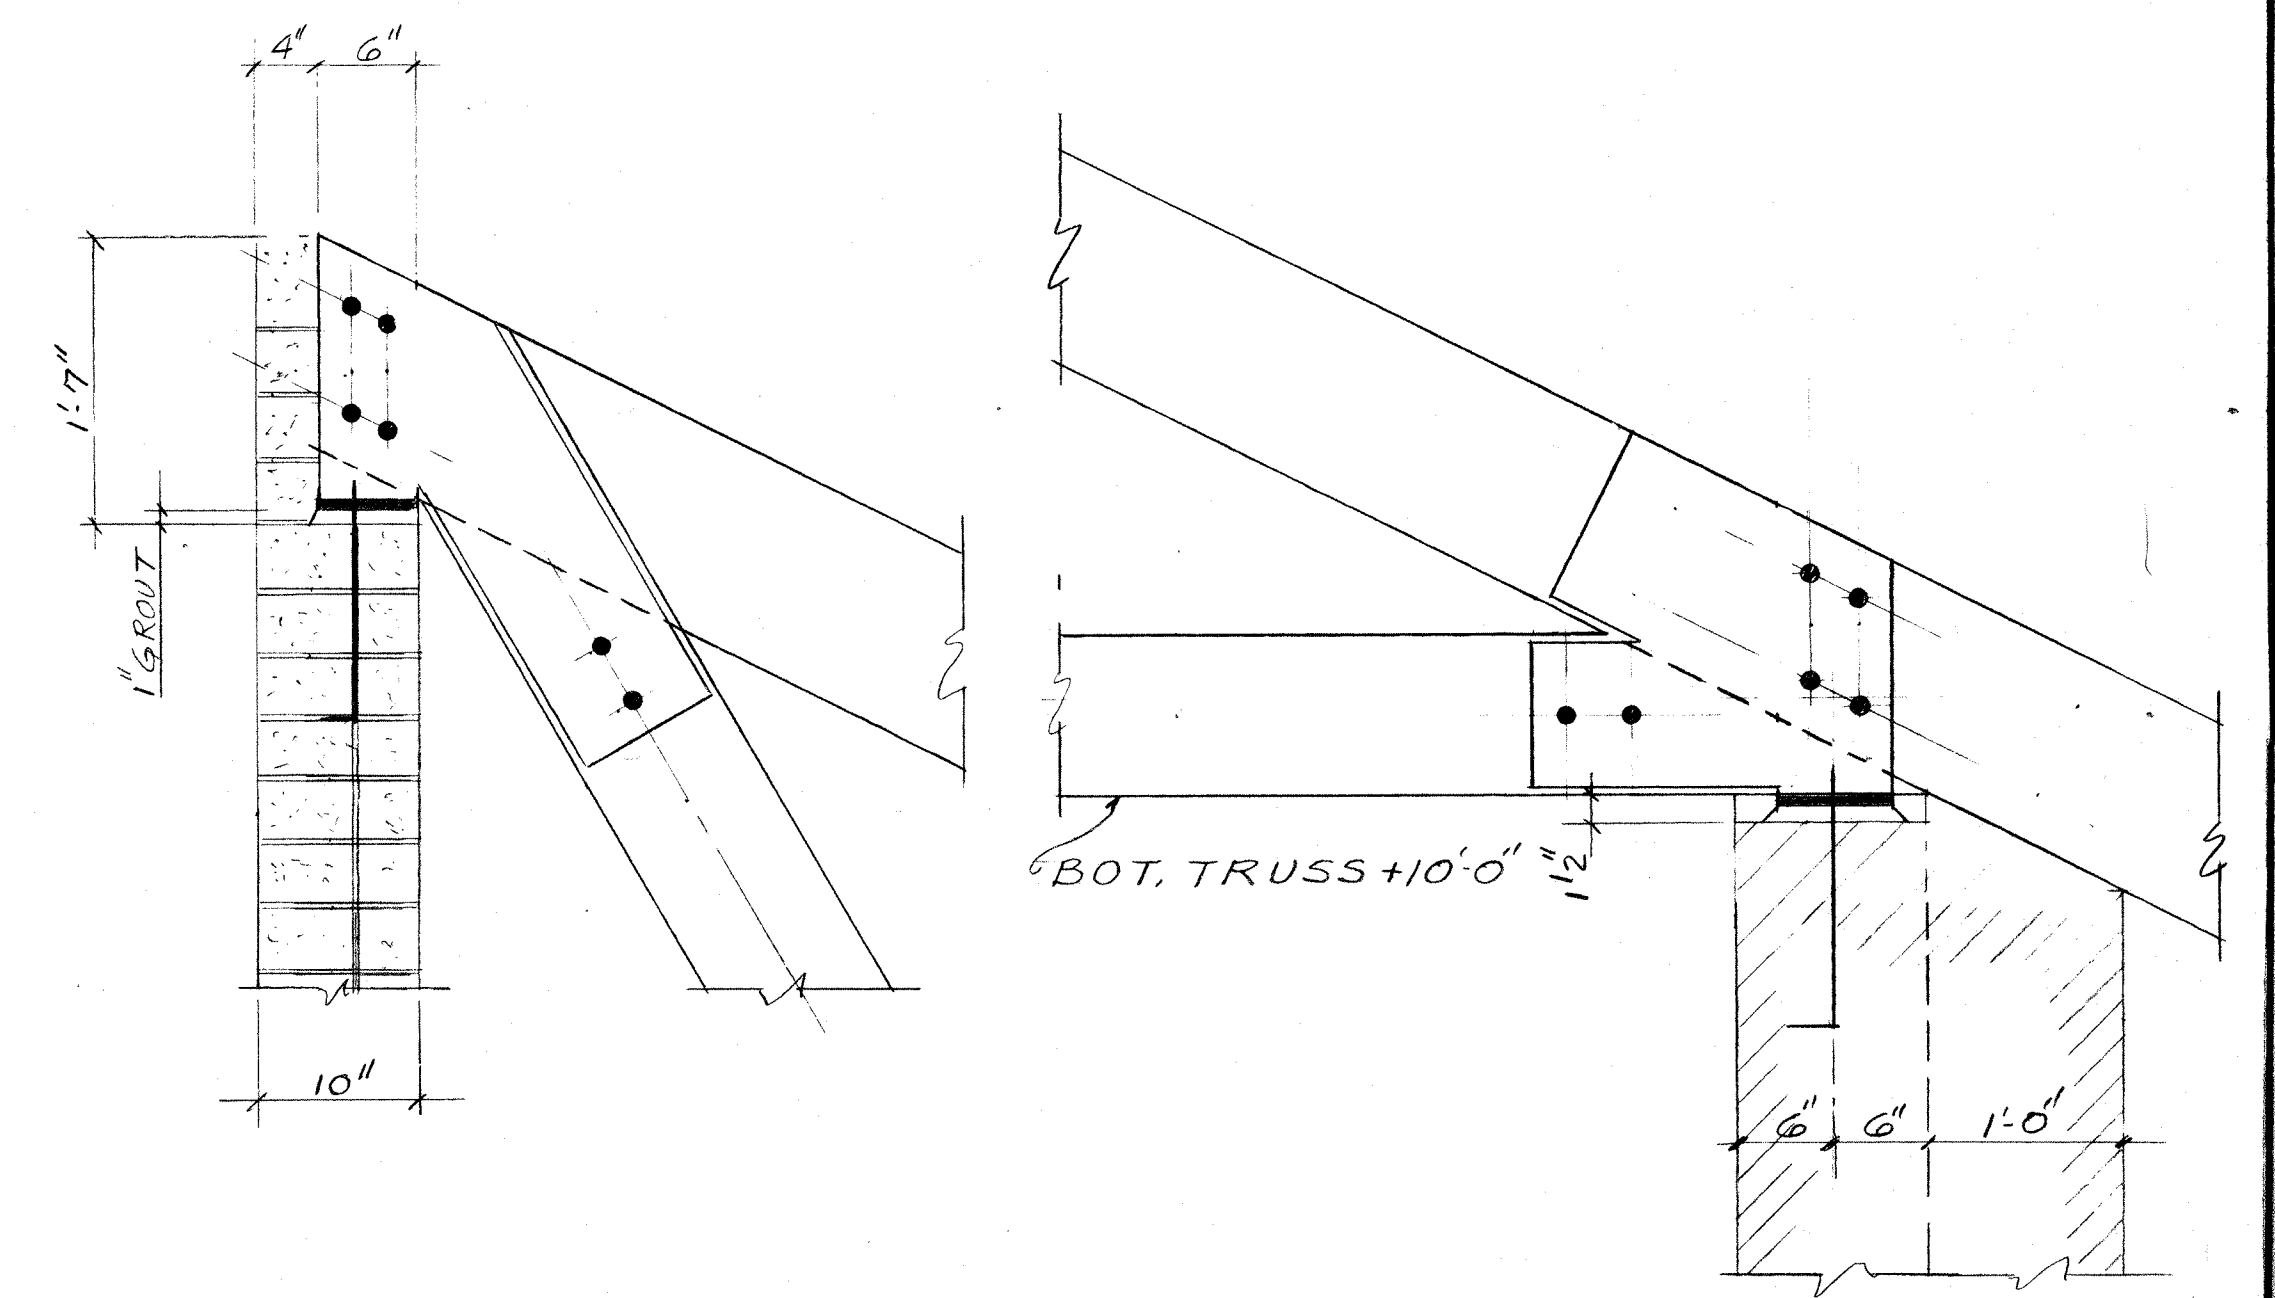


CONNECTION "A"


CONNECTION "B"

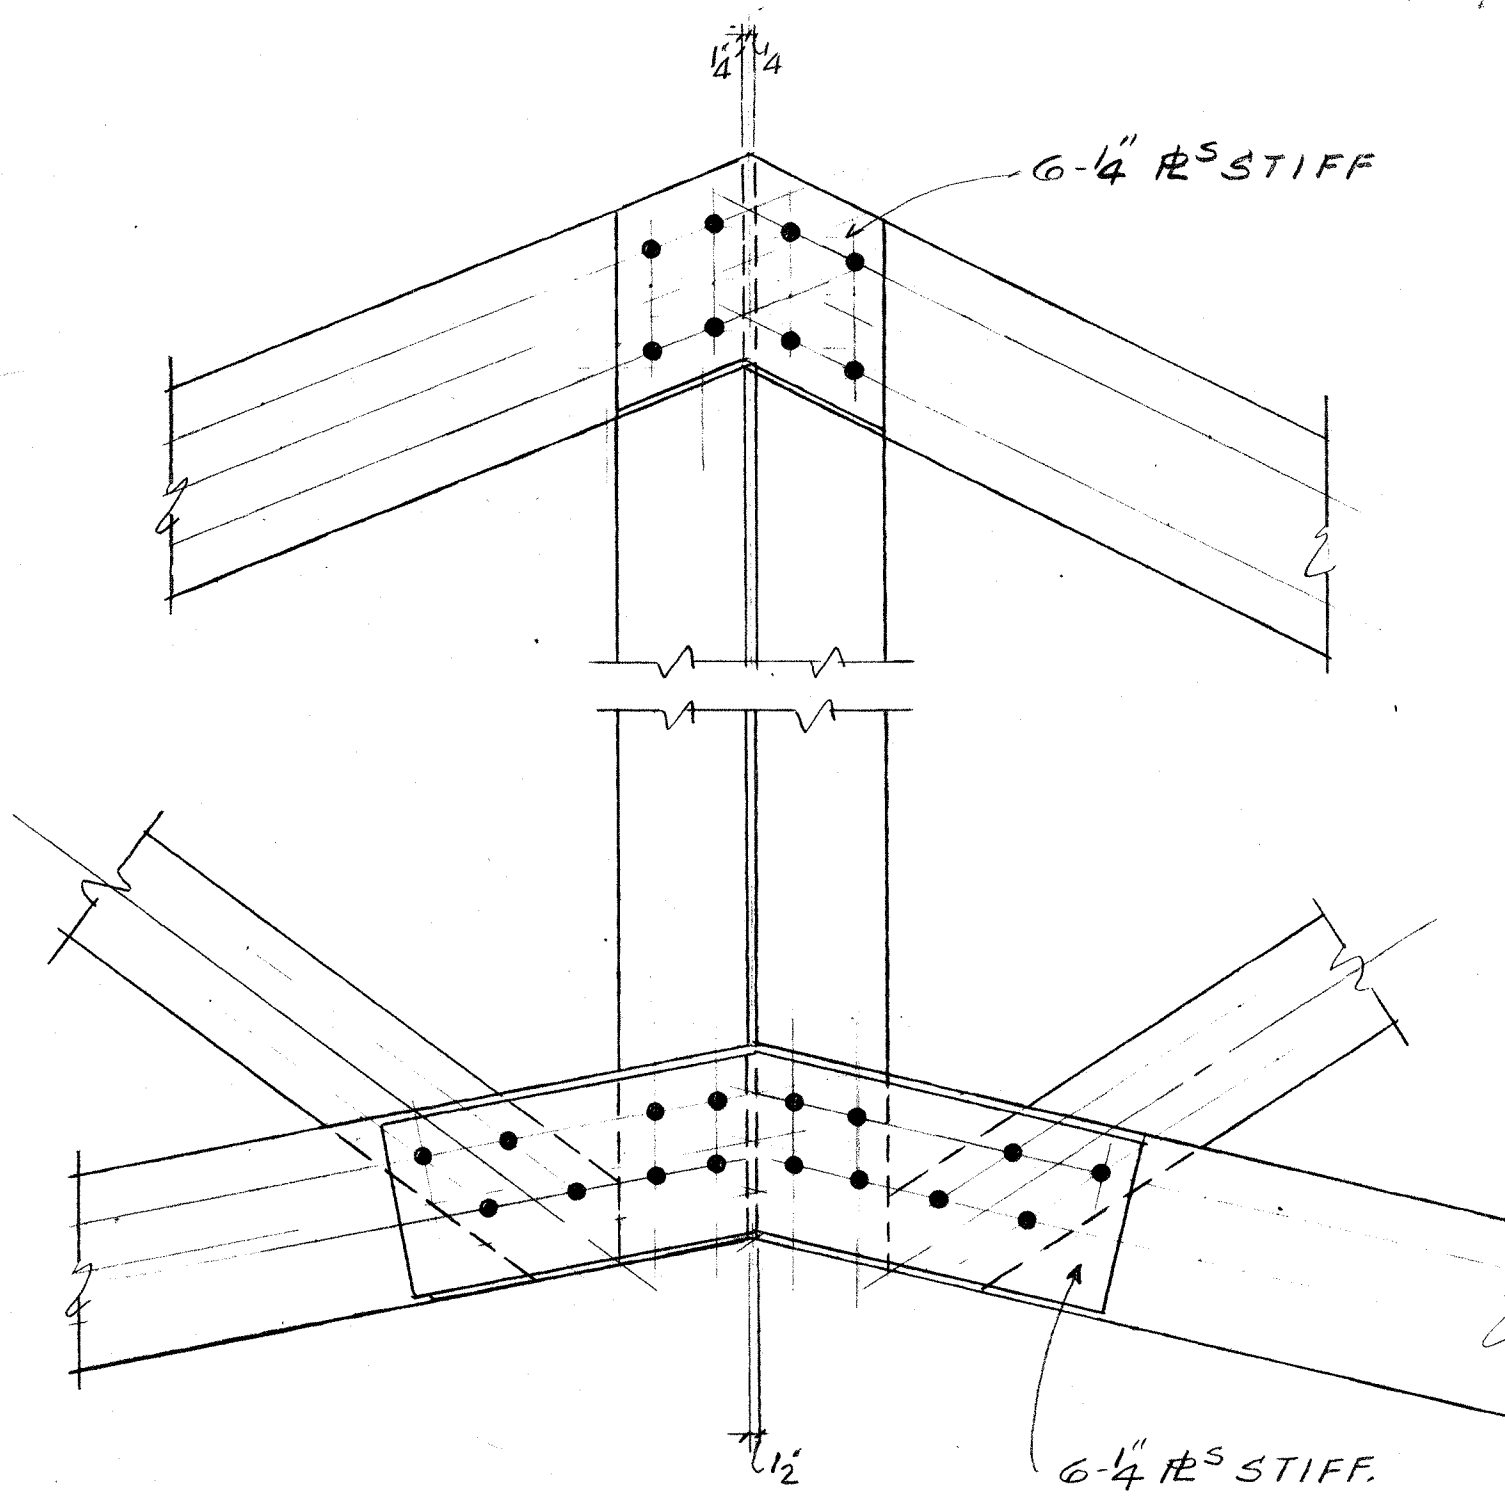

CENTER CONNECTION WT3

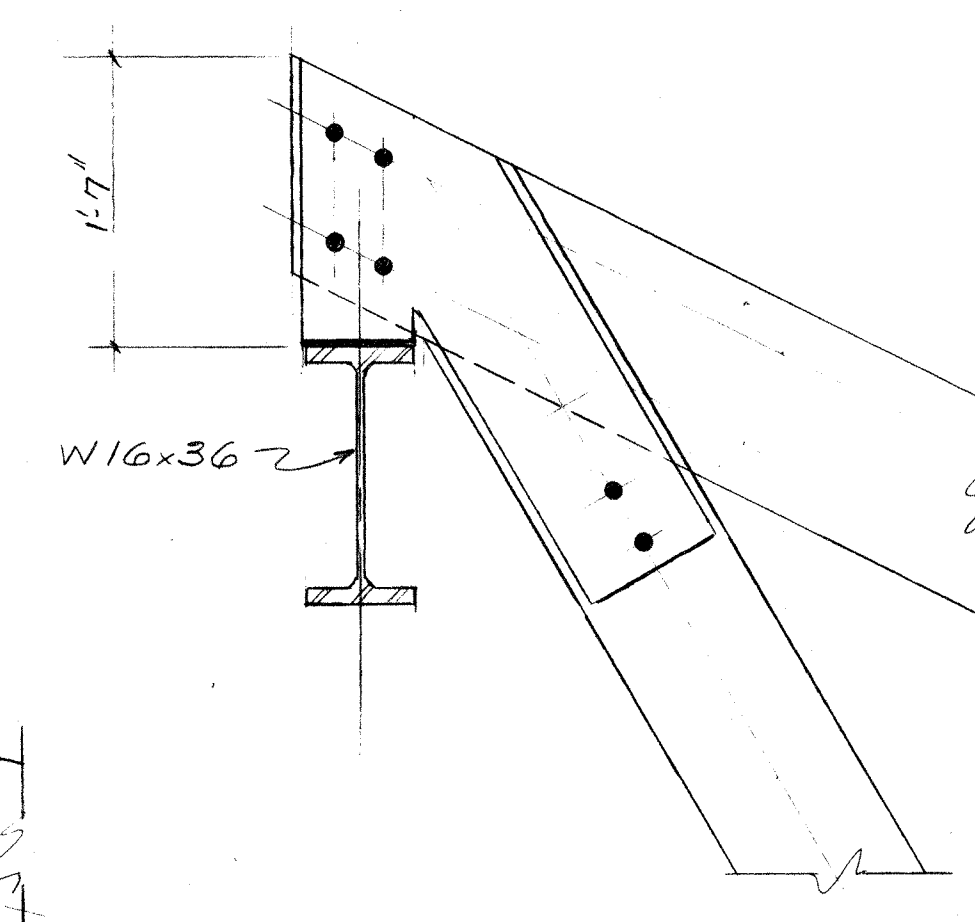

SECTION 1

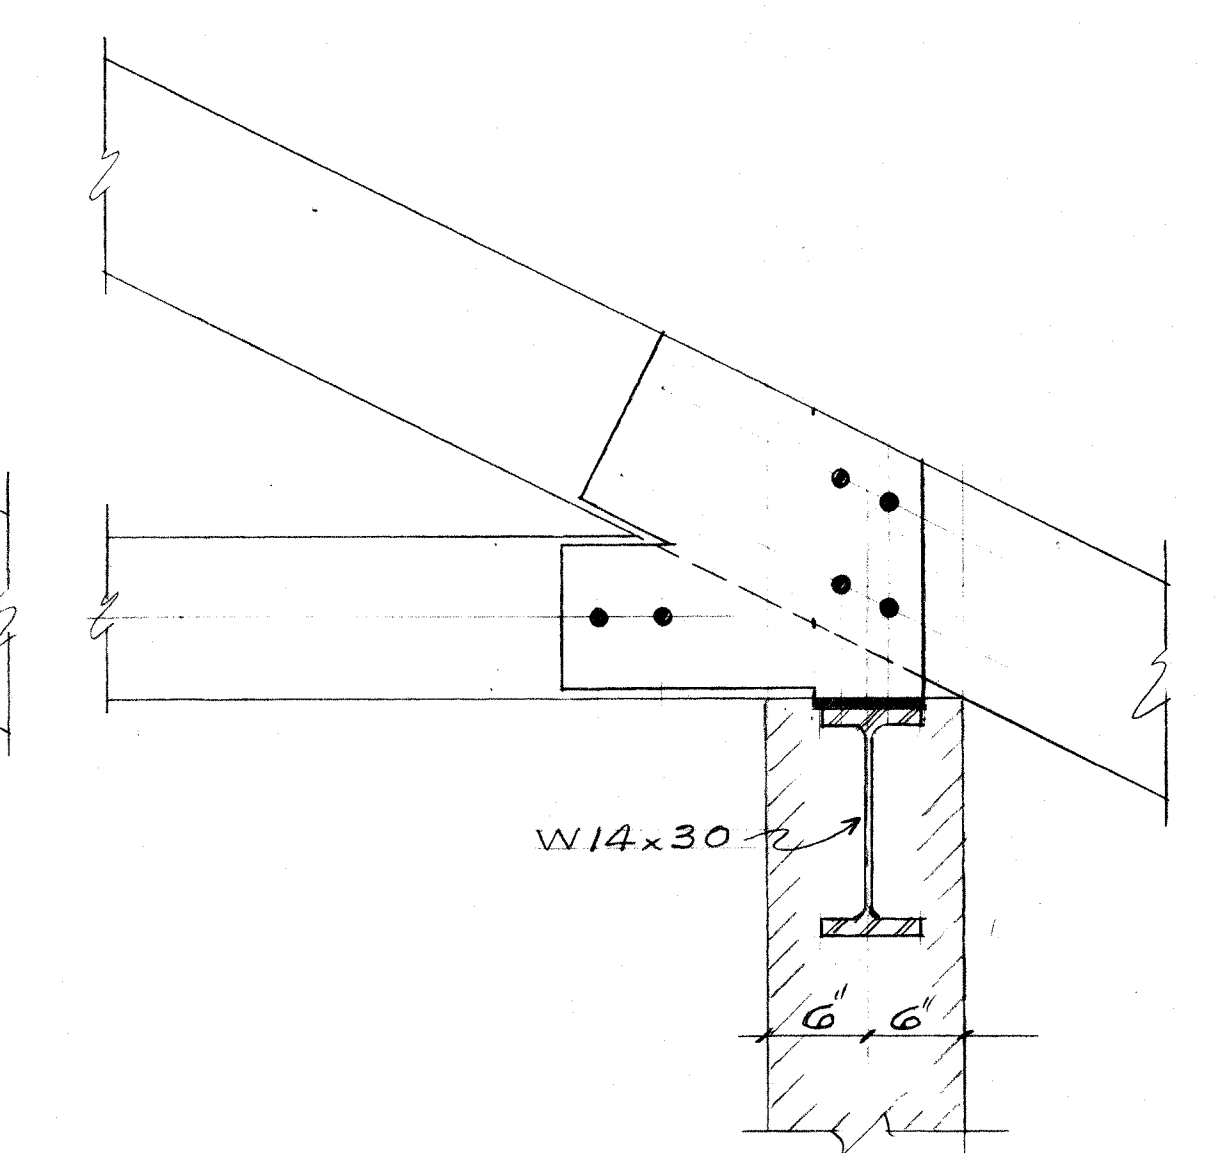

SECTION 2

WOOD TRUSS
ELEVATIONS & DETAILS

Hastings & Chivetta Architects
7733 Forsyth Boulevard, Clayton, Missouri 63105 314-863-5717
Frank A. Romano & Associates
Hansen Engineering
Henicke & Theiss

Bellefontaine Neighbors Community Center
MAYOR RAYMOND ZIELINSKI

S5

Job No. 1188
Date: 5 AUG 1991
Revisions:
